



REV	DATE	BY
0 - REVISED SINCE BID	03-04-09	SPT
1 - RECORD DRAWING	04-16-10	

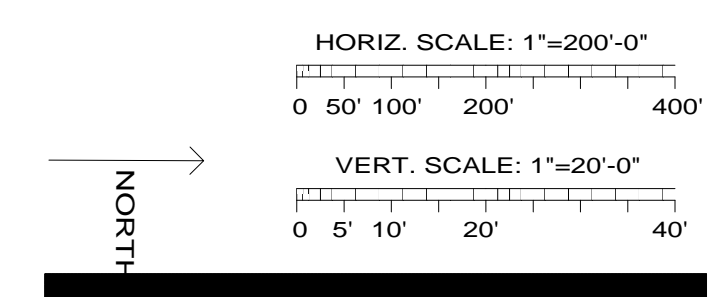

14 STA=22+12.92 1-60/H3 WF-DCTAN 10%+5' EMBED WF-GND WF-EMBD TM-16	15A STA=27+01.07 1-70/H1 WF-STR16-16A 10%+5' EMBED WF-GND WF-EMBD TM-16 (14)WF-GUY-1,(8)WF-GUY-4 (14)WF-GUY-5 WF-DAMPER	16 STA=24+58.63 1-65/H3 WF-DCTAN 10%+5' EMBED WF-GND WF-EMBD TM-16	17 STA=26+37.65 1-70/H1 WF-STR16-16A 10%+5' EMBED WF-GND WF-EMBD TM-16 (14)WF-GUY-1,(8)WF-GUY-4 (14)WF-GUY-5 WF-DAMPER	18 STA=28+90.27 1-60/H3 WF-DCTAN 10%+5' EMBED WF-GND WF-EMBD TM-16	19 STA=30+92.54 1-55/H2 WF-DCTAN 10%+4' EMBED WF-GND WF-EMBD TM-16	20 STA=33+41.72 1-60/H3 WF-DCTAN 10%+5' EMBED WF-GND WF-EMBD TM-16	21 STA=35+78.89 1-60/H3 WF-DCTAN 10%+5' EMBED WF-GND WF-EMBD TM-16	22 STA=38+39.14 1-60/H3 WF-DCTAN 10%+5' EMBED WF-GND WF-EMBD TM-16	23 STA=40+79.53 1-60/H3 WF-DCTAN 10%+5' EMBED WF-GND WF-EMBD TM-16	24 STA=43+27.60 1-60/H3 WF-DCTAN 10%+5' EMBED WF-GND WF-EMBD TM-16	25 STA=45+53.57 1-60/H3 WF-DCTAN 10%+5' EMBED WF-GND WF-EMBD TM-16	26 STA=47+93.35 1-65/H3 WF-DCTAN 10%+5' EMBED WF-GND WF-EMBD TM-16	27 STA=50+41.07 1-60/H3 WF-DCTAN 10%+5' EMBED WF-GND WF-EMBD TM-16	28 STA=52+87.20 1-60/H3 WF-DCTAN 10%+5' EMBED WF-GND WF-EMBD TM-16	29 STA=55+41.31 1-65/H3 WF-DCTAN 10%+5' EMBED WF-GND WF-EMBD TM-16	30 STA=57+87.16 1-60/H3 WF-DCTAN 10%+5' EMBED WF-GND WF-EMBD TM-16	31 STA=60+44.99 1-60/H3 WF-DCTAN 10%+5' EMBED WF-GND WF-EMBD TM-16 OPGW-S	32 STA=62+64.52 1-65/H3 WF-DCTAN 10%+5' EMBED WF-GND WF-EMBD TM-16	33 STA=64+95.30 1-70/H3 WF-DCTAN 10%+5' EMBED WF-GND WF-EMBD TM-16	34 STA=67+26.06 1-65/H3 WF-DCTAN 10%+5' EMBED WF-GND WF-EMBD, CULVERT TM-16	35 STA=69+22.78 1-60/H2 WF-DCTAN 10%+4' EMBED WF-GND WF-EMBD TM-16	36 STA=71+19.62 1-60/H2 WF-DCTAN 10%+4' EMBED WF-GND WF-EMBD TM-16
---	---	---	--	---	---	---	---	---	---	---	---	---	---	---	---	---	---	---	---	--	---	---

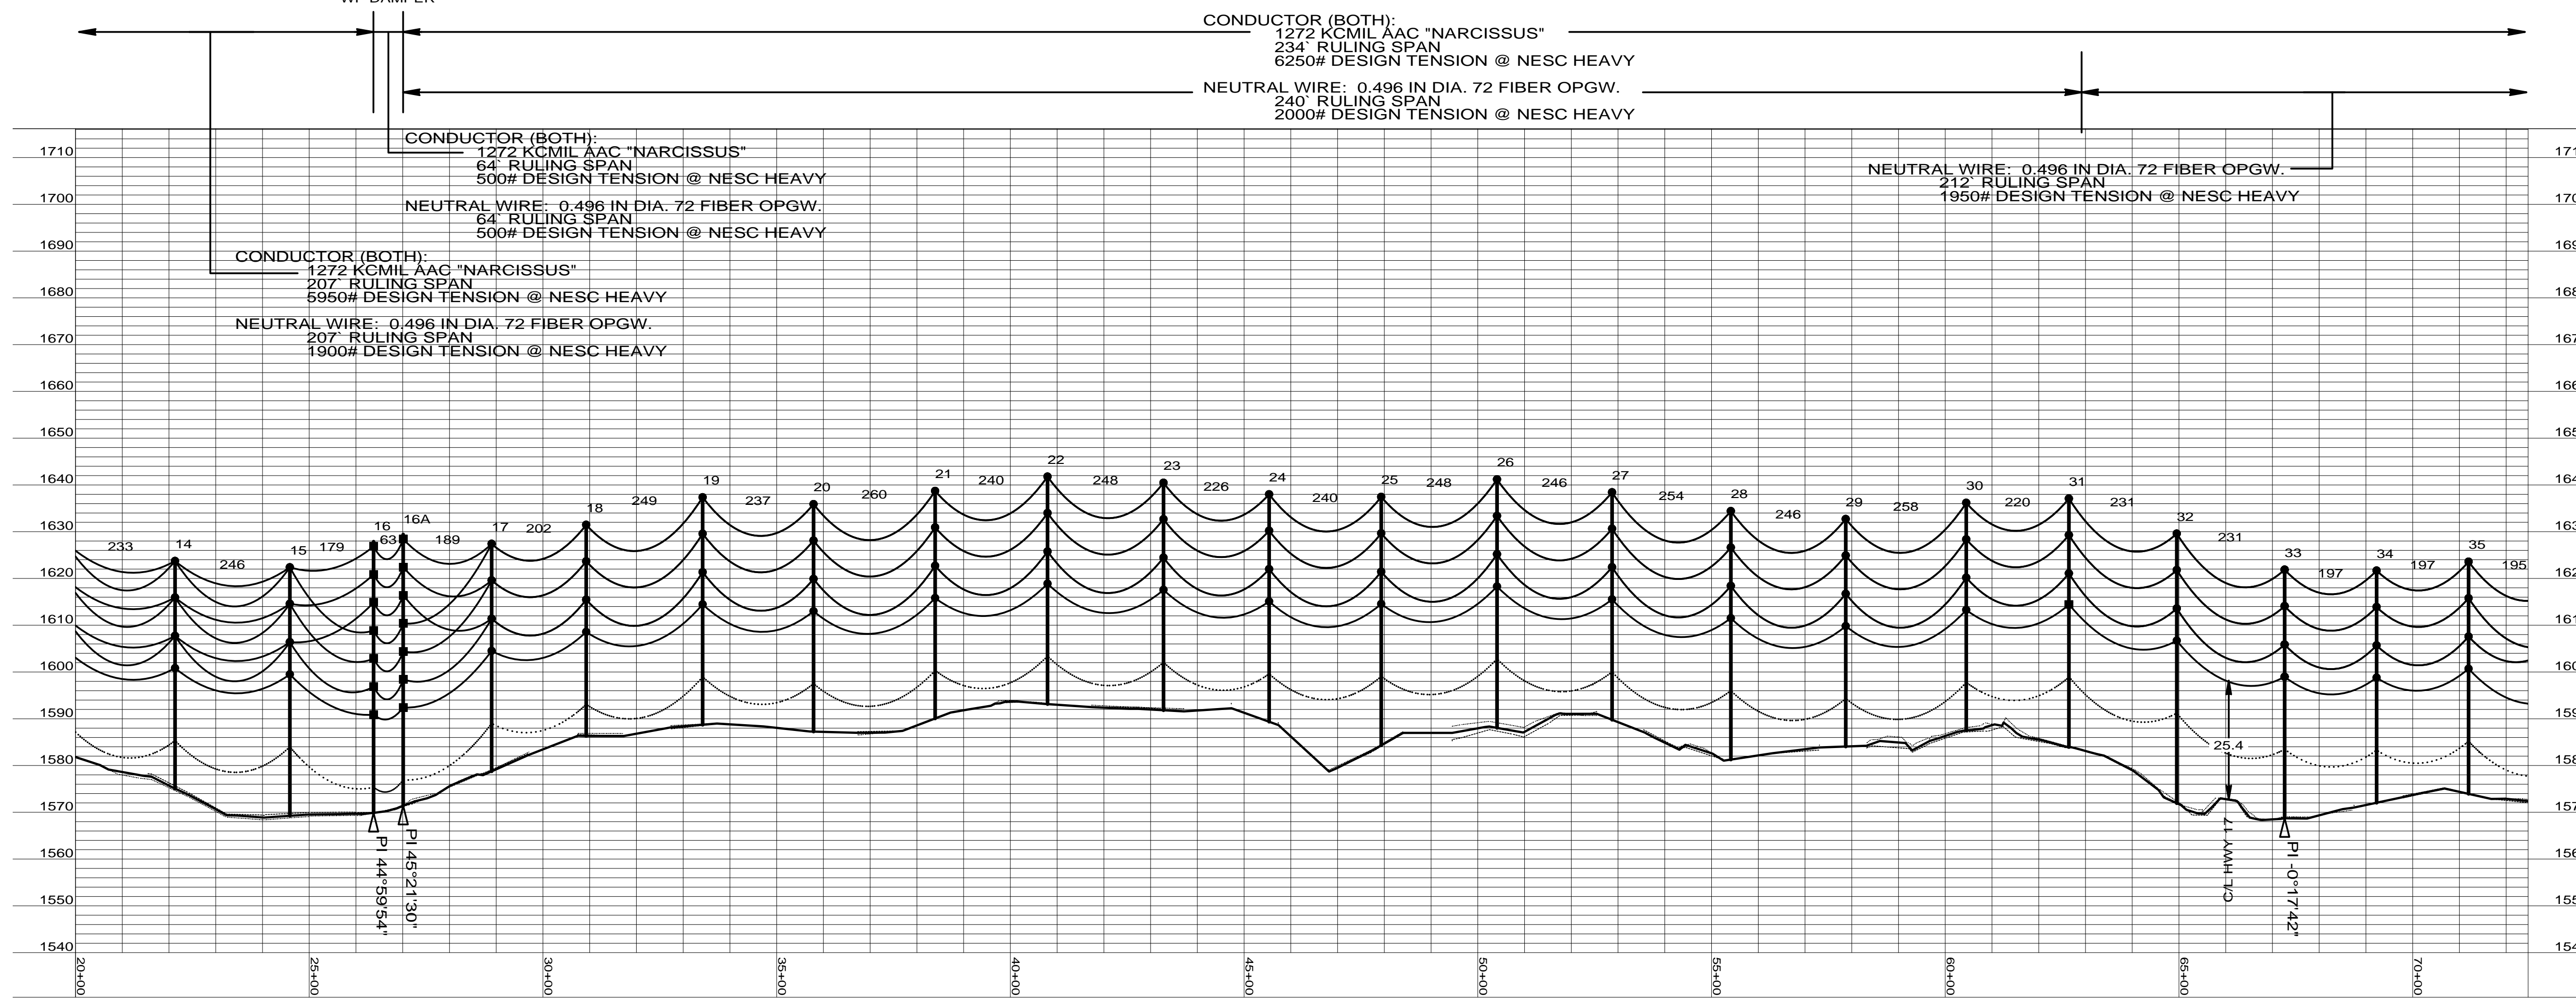

5201 EAST RIVER ROAD, SUITE 308  
MINNEAPOLIS, MINNESOTA 55421  
PHONE: 763.571.2500 FAX: 763.571.1168  
WEB: WWW.ULTEIG.COM  
DRAWN BY: NGK  
CHECKED BY: MPK  
APPROVED BY: SPT

**RUGBY 34.5KV  
TRANSMISSION LINE  
PLAN AND PROFILE**

PROJECT NUMBER: 108.0495  
DATE CREATED: DECEMBER 3, 2008  
DWG NO: RUG-E-511-02