



| Rev | Date | By |
|-----------------------|----------|-----|
| 0 - REVISED SINCE BID | 03-04-09 | SPT |
| 1 - STR #82 & 83 MOVE | 05-15-09 | SPT |
| 2 - RECORD DRAWING | 04-16-10 | |

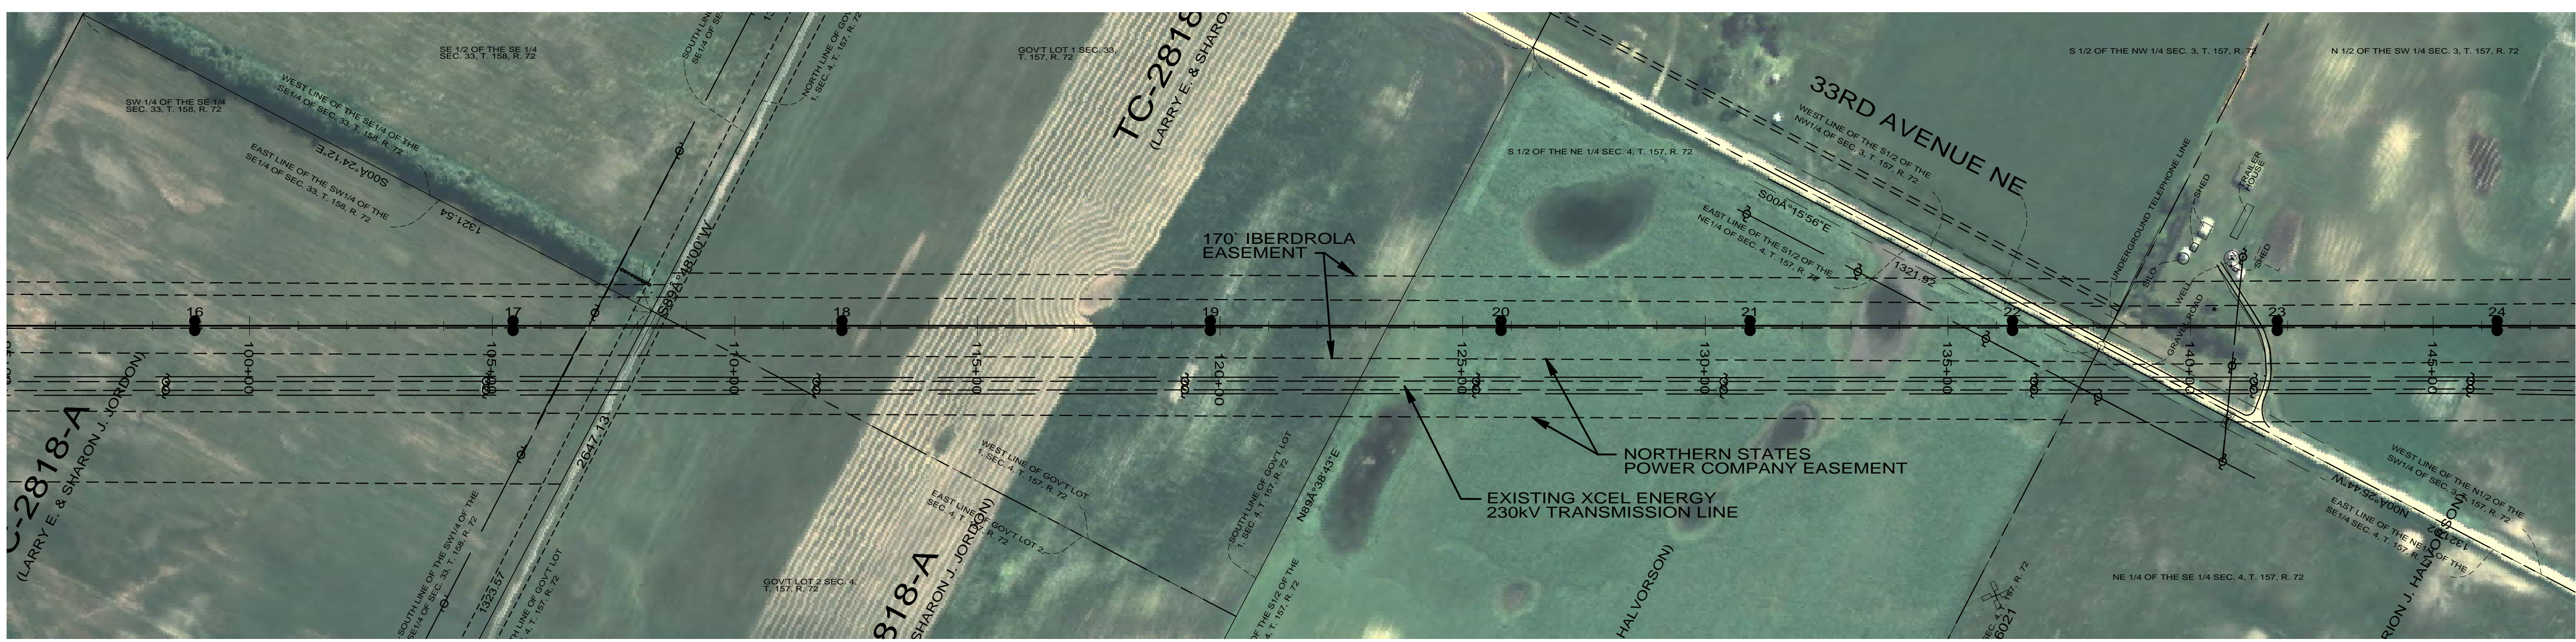

| | | | | | | | | |
|---|---|--|--|--|--|---|--|--|
| 16 sta=98+87.01 2-85/2 HF-TAN GND DETAILS EMBED TM-16 | 17 sta=105+43.11 2-100/2 HF-TAN GND DETAILS EMBED TM-16 | 18 sta=112+20.79 2-90/2 HF-TAN GND DETAILS EMBED TM-16 | 19 sta=119+79.85 2-75/2 HF-TAN GND DETAILS EMBED TM-16 | 20 sta=125+79.00 2-80/2 HF-TAN GND DETAILS EMBED TM-16 | 21 sta=130+92.27 2-80/2 HF-TAN GND DETAILS EMBED TM-16 | 22 sta=136+33.24 2-85/2 HF-TAN-OPGW-S GND DETAILS EMBED TM-16 OPGW-S | 23 sta=141+78.76 2-85/2 HF-TAN GND DETAILS EMBED TM-16 | 24 sta=146+31.97 2-80/2 HF-TAN GND DETAILS EMBED TM-16 |
|---|---|--|--|--|--|---|--|--|

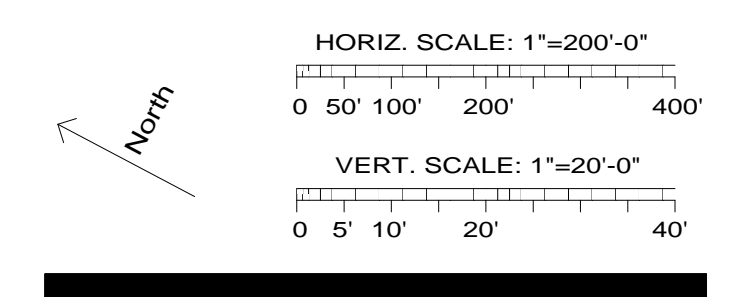

Bismarck-Denver-Detroit Lakes-Fargo-Minneapolis-Sioux Falls
 5201 East River Road, Suite 308
 Minneapolis, Minnesota 55421
 Phone: 763.571.2500 Fax: 763.571.1168
 Web: www.ulteig.com
 Drawn By: NGK
 Checked By: MPM
 Approved By: SPT

**RUGBY 230kV
 TRANSMISSION LINE
 PLAN AND PROFILE**

Project Number: 108.0495
 Date Created: December 3, 2008
 Dwg No: **RUG-E-515-03**