

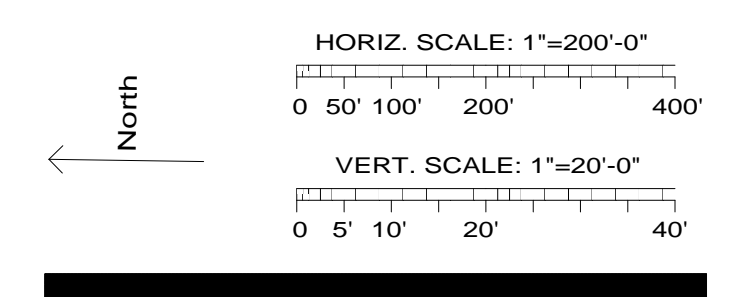


Rev	Date	By
0 - REVISED SINCE BID	03-04-09	SPT
1 - STR #82 & 83 MOVE	05-15-09	SPT
2 - RECORD DRAWING	04-16-10	

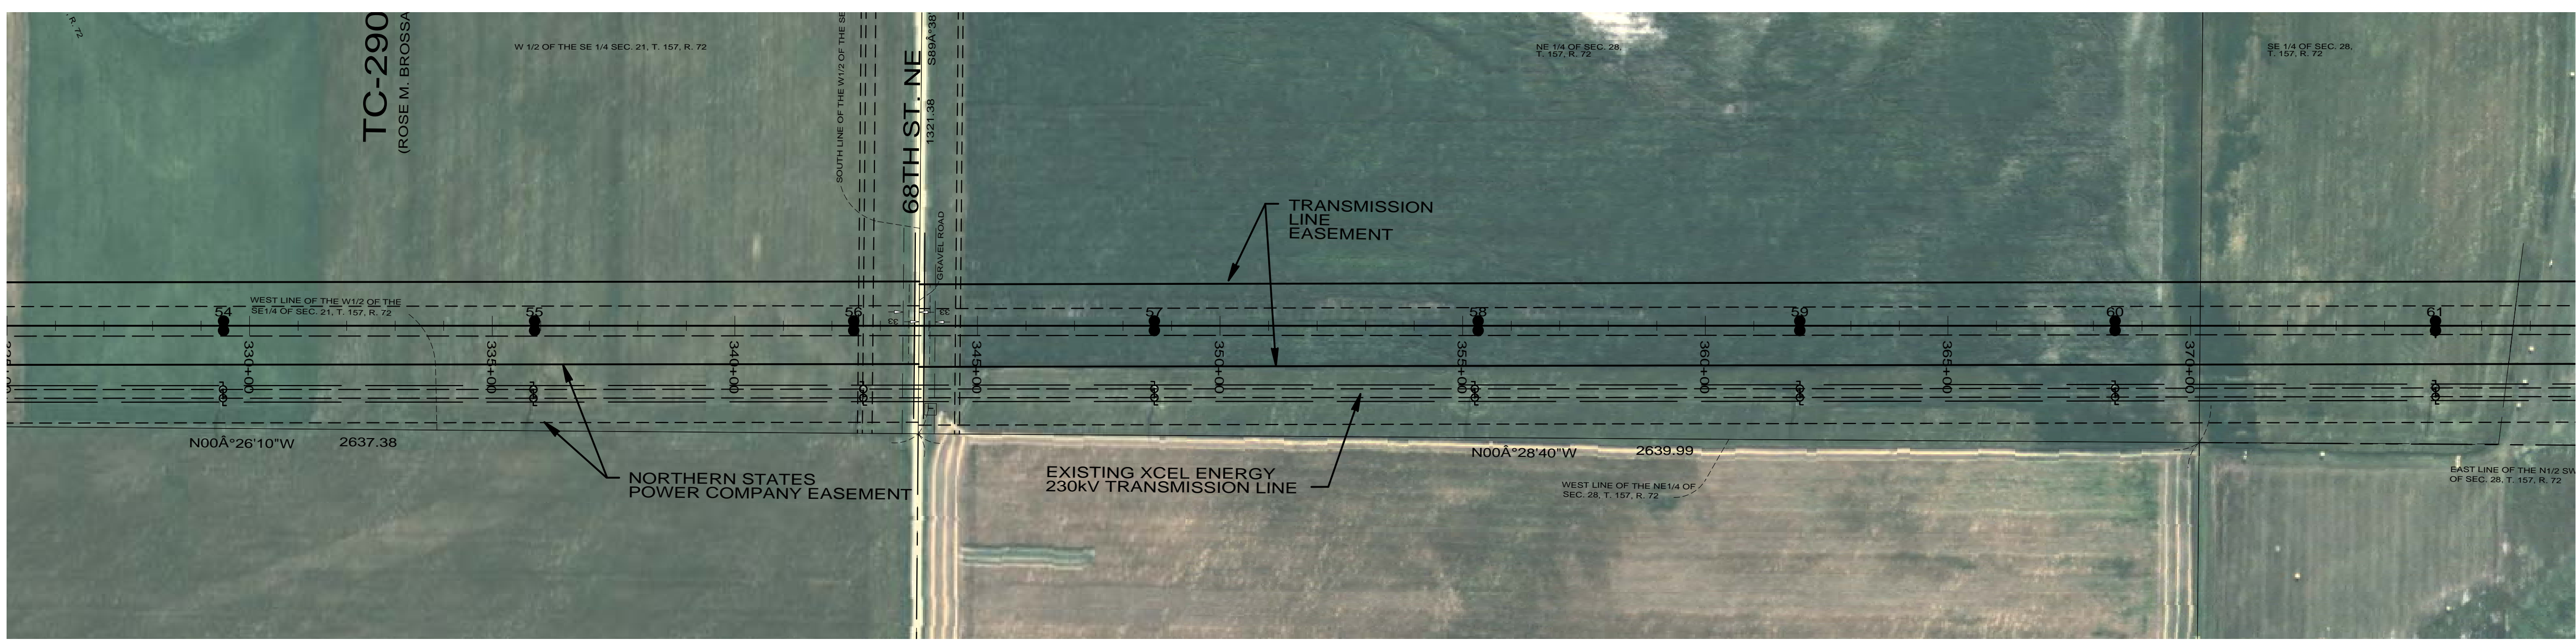

54 sta=329+46.47 2-85/2 HF-TAN GND DETAILS EMBED TM-16	55 sta=335+87.35 2-80/2 HF-TAN GND DETAILS EMBED TM-16	56 sta=342+45.01 2-80/2 HF-TAN-OPGW-S GND DETAILS EMBED TM-16 OPGW-S	57 sta=348+64.76 2-85/2 HF-TAN GND DETAILS EMBED TM-16	58 sta=355+31.93 2-80/2 HF-TAN GND DETAILS EMBED TM-16	59 sta=361+94.84 2-80/2 HF-TAN GND DETAILS EMBED TM-16	60 sta=368+44.60 2-80/2 HF-TAN GND DETAILS EMBED TM-16	61 sta=375+04.98 2-80/2 HF-TAN GND DETAILS EMBED TM-16
--	--	---	--	--	--	--	--

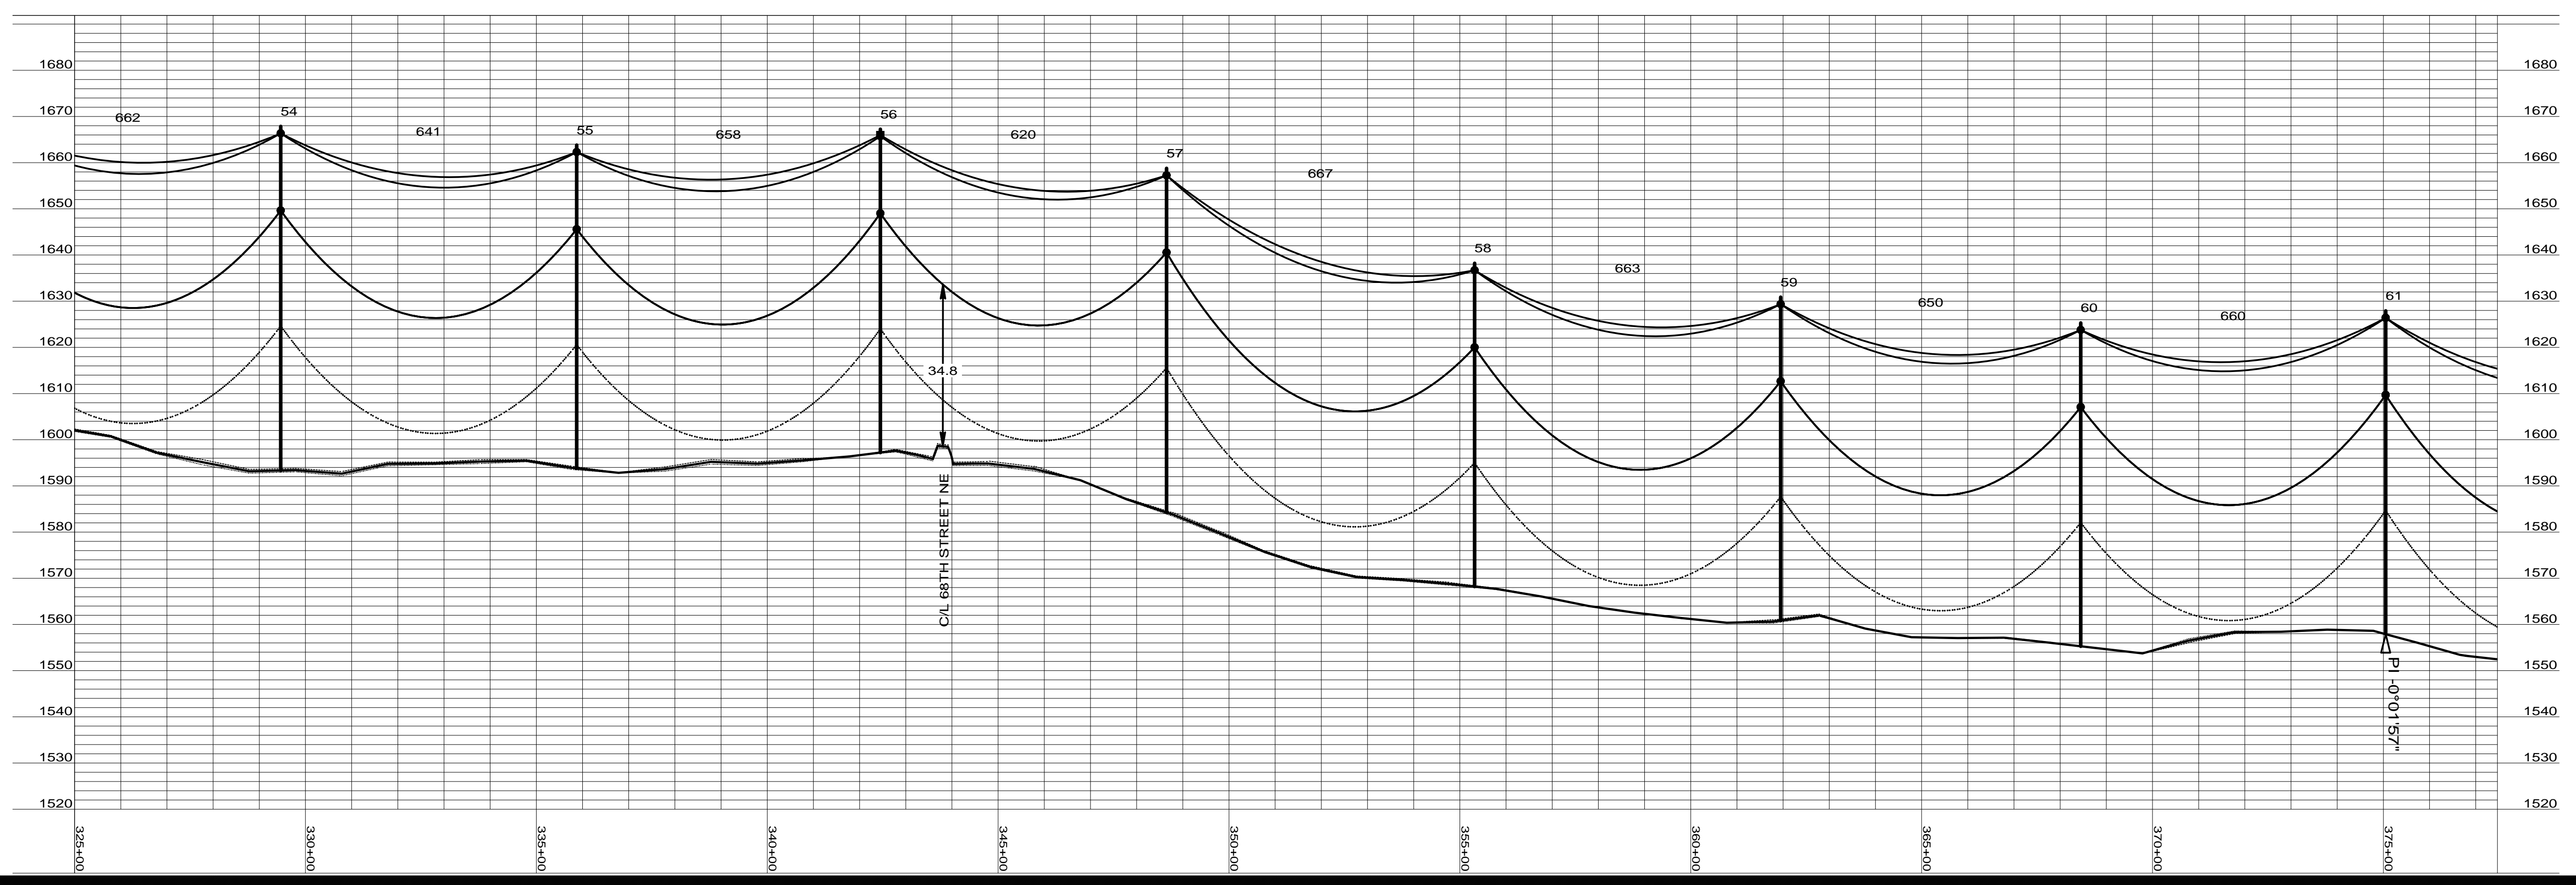

Bismarck-Denver-Detroit Lakes-Fargo-Minneapolis-Sioux Falls
 5201 East River Road, Suite 308
 Minneapolis, Minnesota 55421
 Phone: 763.571.2500 Fax: 763.571.1168
 Web: www.ulteig.com
 Drawn By: NGK
 Checked By: MPM
 Approved By: SPT

**RUGBY 230kV
 TRANSMISSION LINE
 PLAN AND PROFILE**

Project Number: 108.0495
 Date Created: December 3, 2008
 Dwg No: **RUG-E-515-08**