



REV	DATE	BY
0 - REVISED SINCE BID	03-04-09	SPT
1 - RECORD DRAWING	04-16-10	

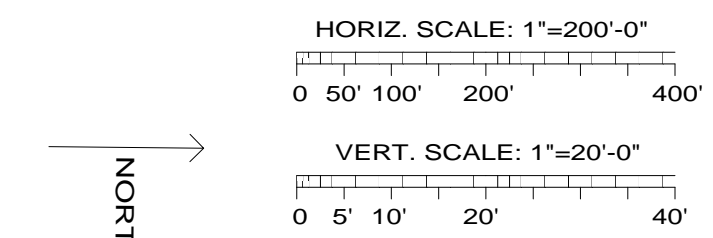

56 STA=121+58.34 1-50/1 WF-TAN-1 WF-GND WF-EMBD TM-16	57 STA=124+01.84 1-45/1 WF-TAN-1 WF-GND WF-EMBD TM-16	58 STA=126+55.62 1-50/1 WF-TAN-1 WF-GND WF-EMBD TM-16	59 STA=129+00.26 1-50/1 WF-TAN-1 WF-GND WF-EMBD TM-16	60 STA=131+41.62 1-55/1 WF-TAN-1 WF-GND WF-EMBD TM-16	61 STA=133+82.97 1-55/1 WF-TAN-1 WF-GND WF-EMBD TM-16	62 STA=136+02.65 1-45/1 WF-TAN-1 WF-GND WF-EMBD TM-16	63 STA=138+32.06 1-45/1 WF-TAN-1 WF-GND WF-EMBD TM-16	64 STA=140+68.11 1-50/1 WF-TAN-1 WF-GND WF-EMBD TM-16	65 STA=143+20.84 1-55/1 WF-TAN-1 WF-GND WF-EMBD TM-16	66 STA=145+76.05 1-50/1 WF-TAN-1 WF-GND WF-EMBD TM-16	67 STA=148+32.49 1-45/1 WF-TAN-1 WF-GND WF-EMBD TM-16	68 STA=150+85.22 1-55/1 WF-TAN-1 WF-GND WF-EMBD TM-16	69 STA=153+31.76 1-45/1 WF-TAN-1 WF-GND WF-EMBD TM-16	70 STA=155+86.66 1-45/H1 WF-TAN-1 10%+3' EMBED WF-GND WF-EMBD TM-16	71 STA=158+11.16 1-60/H2 WF-ANG-1 10%+4' EMBED WF-GND WF-EMBD TM-16	72 STA=160+23.00 1-65/H3 WF-ANG-1 10%+5' EMBED WF-GND WF-EMBD TM-16	73 STA=162+46.24 WF-TAN-1 10%+3' EMBED WF-GND WF-EMBD TM-16	74 STA=164+53.61 1-45/1 WF-TAN-1 WF-GND WF-EMBD TM-16	75 STA=166+76.22 1-60/H3 WF-TAN-1 10%+5' EMBED WF-GND WF-EMBD TM-16	76 STA=169+09.16 1-60/H4 WF-TAN-1 10%+6' EMBED WF-GND WF-EMBD TM-16	77 STA=171+30.23 1-65/1 1-50/1 WF-DE-RISER OPGW-S WF-GND WF-EMBD TM-16 (4)WF-GUY-2 (4)WF-GUY-3 (3)WF-GUY-4 (4)WF-GUY-5 WF-DAMPER
---	---	---	---	---	---	---	---	---	---	---	---	---	---	--	--	--	---	---	--	--	--

CONDUCTOR:
1272 KCMIL AAC "NARCISSUS"
242' RULING SPAN
6350# DESIGN TENSION @ NESC HEAVY

NEUTRAL WIRE: 0.496 IN DIA. 72 FIBER OPGW.
242' RULING SPAN
2050# DESIGN TENSION @ NESC HEAVY

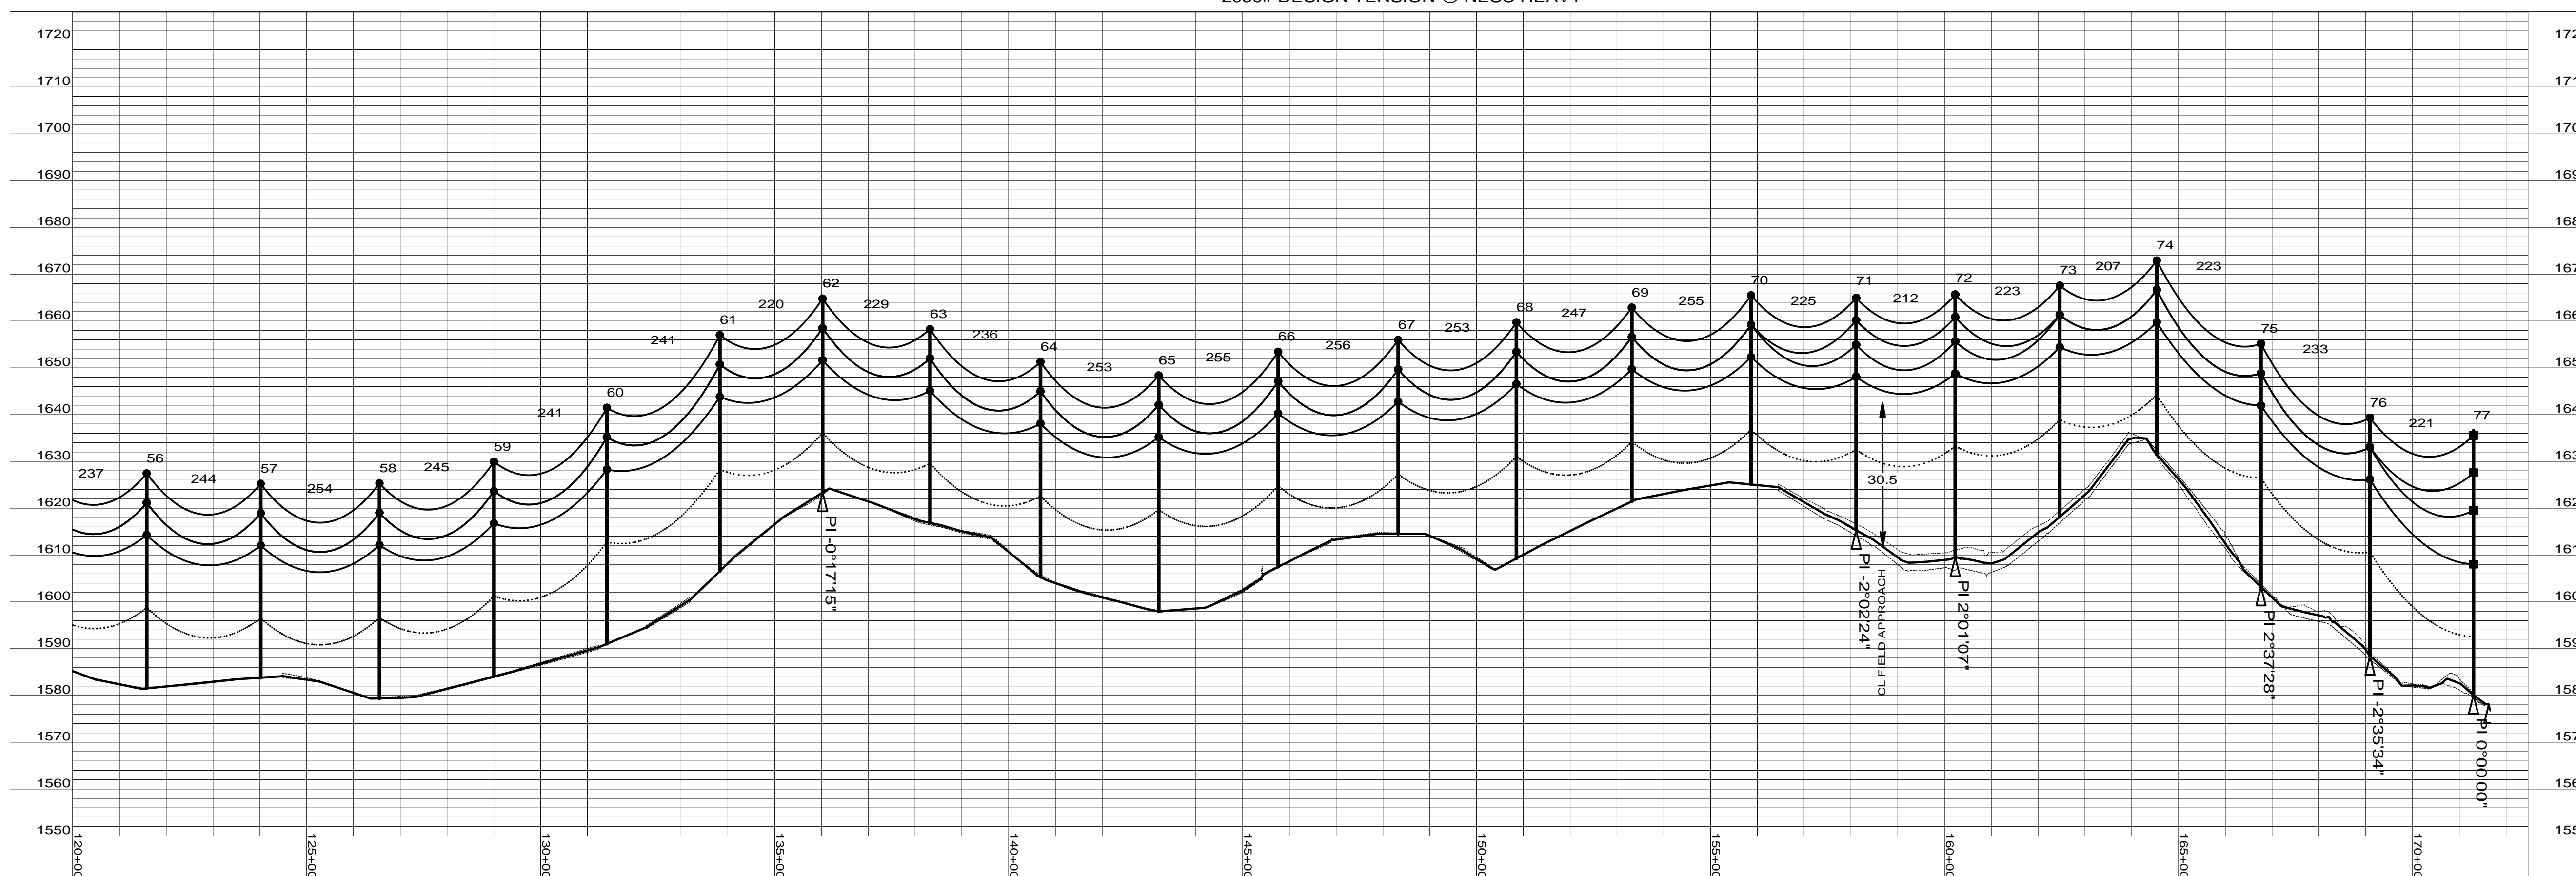

5201 EAST RIVER ROAD, SUITE 308
MINNEAPOLIS, MINNESOTA 55421
PHONE: 763.571.2500 FAX: 763.571.1168
WEB: WWW.ULTEIG.COM
DRAWN BY: NGK
CHECKED BY: MPM
APPROVED BY: SPT

RUGBY 34.5KV
TRANSMISSION LINE
PLAN AND PROFILE

PROJECT NUMBER: 108.0495
DATE CREATED: DECEMBER 3, 2008
DWG NO: RUG-E-511-04