




REV	DATE	BY
0 - REVISED SINCE BID	03-04-09	SPT
1 - RECORD DRAWING	04-16-10	

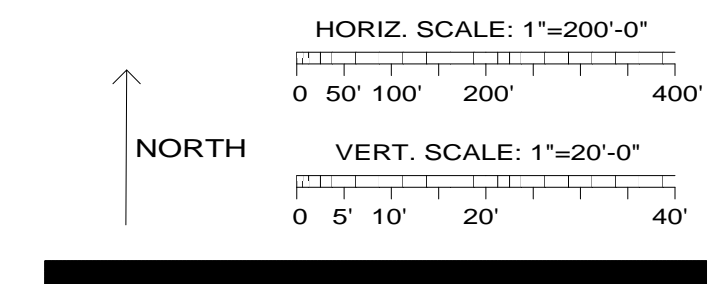

- |   |   |   |   |  |
|---|---|---|---|--|
| <p>141<br/>STA=331+39.42<br/>1-45/1<br/>WF-TAN-1<br/>WF-GND<br/>WF-EMBD<br/>TM-16</p> | <p>142<br/>STA=333+62.40<br/>1-45/1<br/>WF-TAN-1<br/>WF-GND<br/>WF-EMBD<br/>TM-16</p> | <p>143<br/>STA=336+16.09<br/>1-55/1<br/>WF-TAN-1<br/>WF-GND<br/>WF-EMBD<br/>TM-16</p> | <p>144<br/>STA=338+23.07<br/>1-55/1<br/>WF-TAN-1<br/>WF-GND<br/>WF-EMBD<br/>TM-16</p> | <p>145<br/>STA=339+31.69<br/>1-60/1 1-50/1<br/>WF-DE-RISER<br/>OPGW-S<br/>WF-GND<br/>WF-EMBD<br/>TM-16<br/>(4)WF-GUY-2,(4)WF-GUY-3<br/>(3)WF-GUY-4,(4)WF-GUY-5<br/>WF-DAMPER</p> |
|---|---|---|---|--|

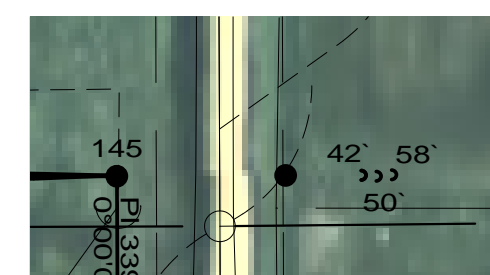

GUY DETAIL STR145

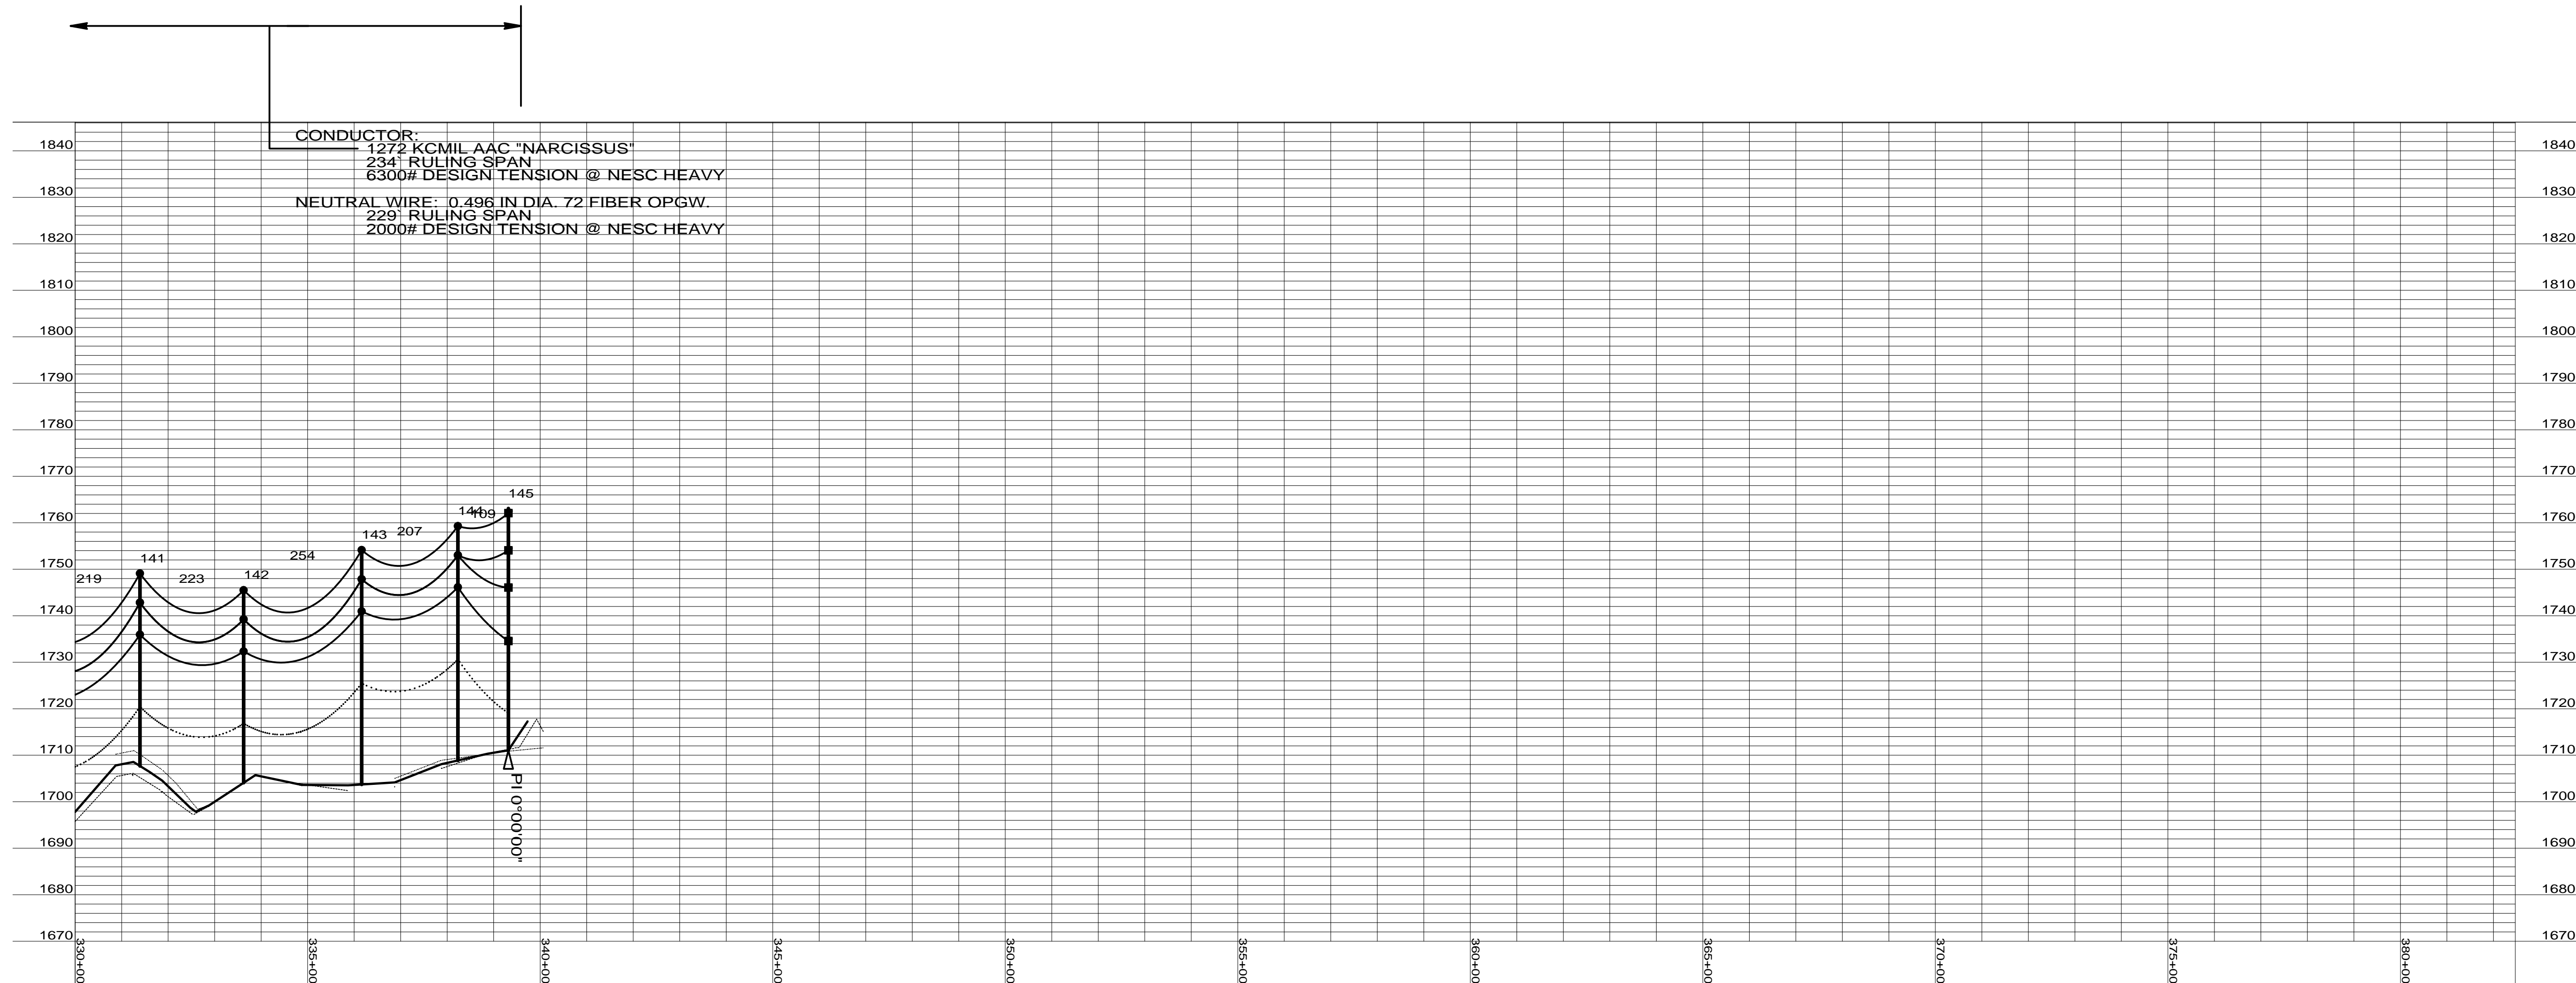

5201 EAST RIVER ROAD, SUITE 308  
MINNEAPOLIS, MINNESOTA 55421  
PHONE: 763.571.2500 FAX: 763.571.1168  
WEB: WWW.ULTEIG.COM  
DRAWN BY: NGK  
CHECKED BY: MPM  
APPROVED BY: SPT

RUGBY 34.5KV  
TRANSMISSION LINE  
PLAN AND PROFILE

PROJECT NUMBER: 108.0495  
DATE CREATED: DECEMBER 3, 2008  
DWG NO: RUG-E-511-08