

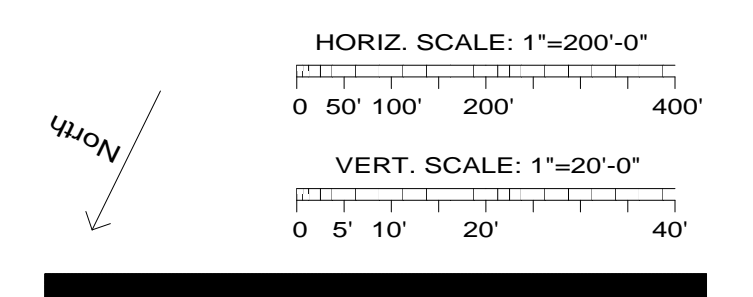
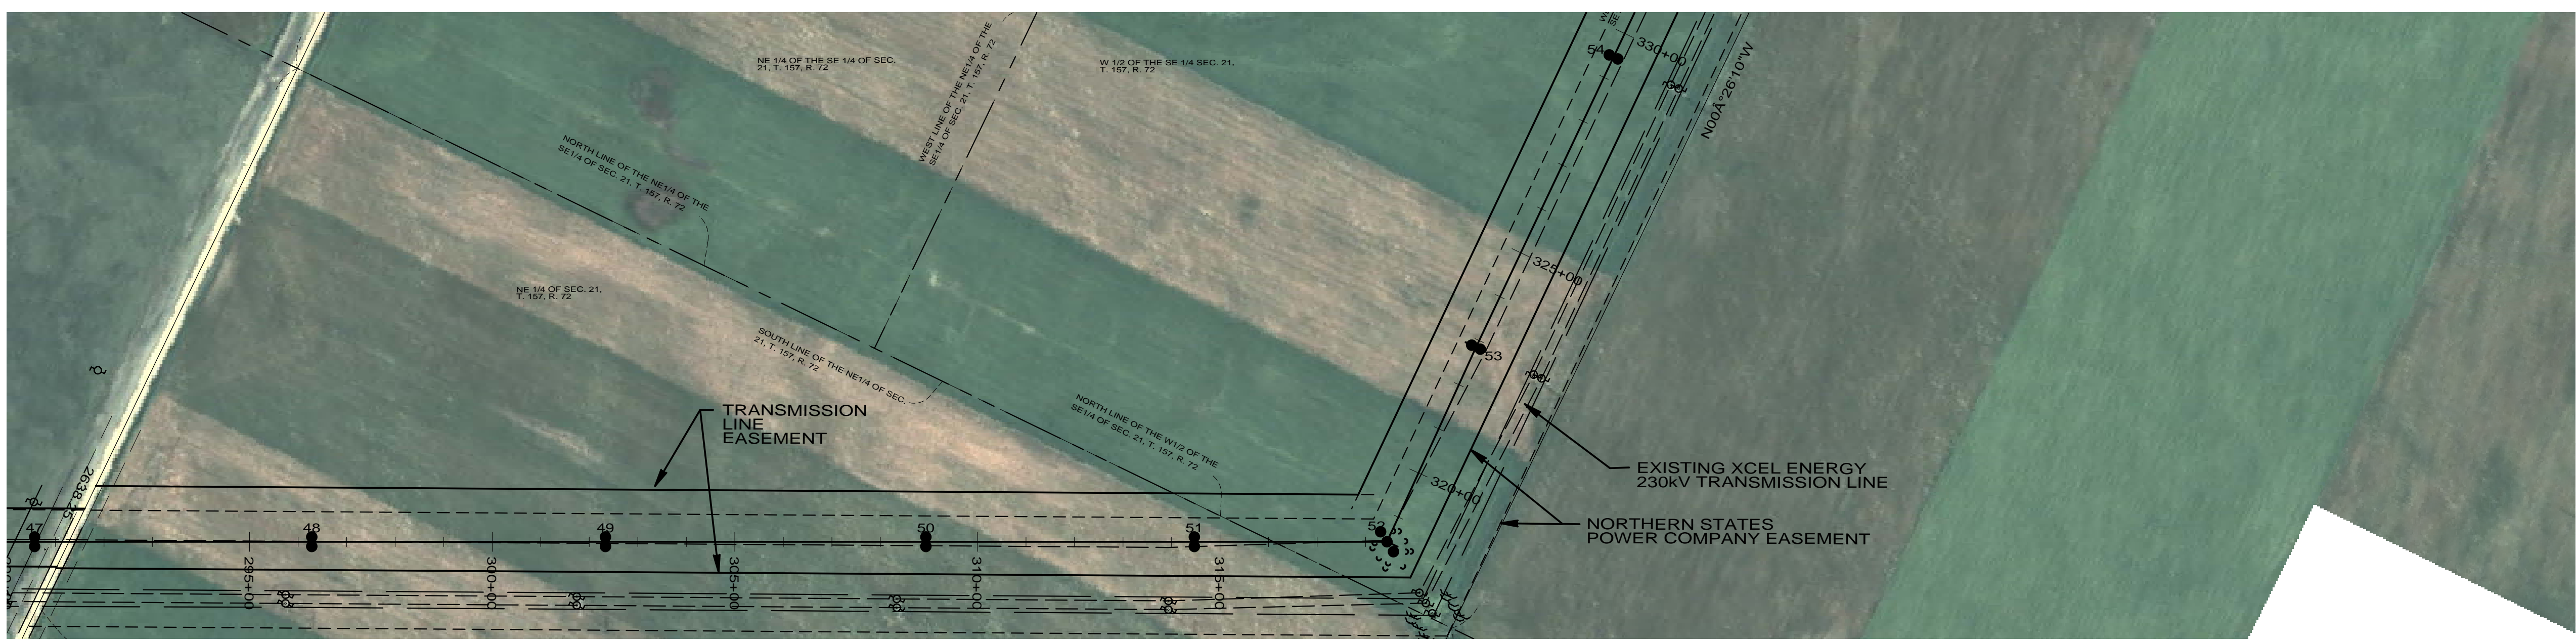


Rev	Date	By
0 - REVISED SINCE BID	03-04-09	SPT
1 - STR #82 & 83 MOVE	05-15-09	SPT
2 - RECORD DRAWING	04-16-10	

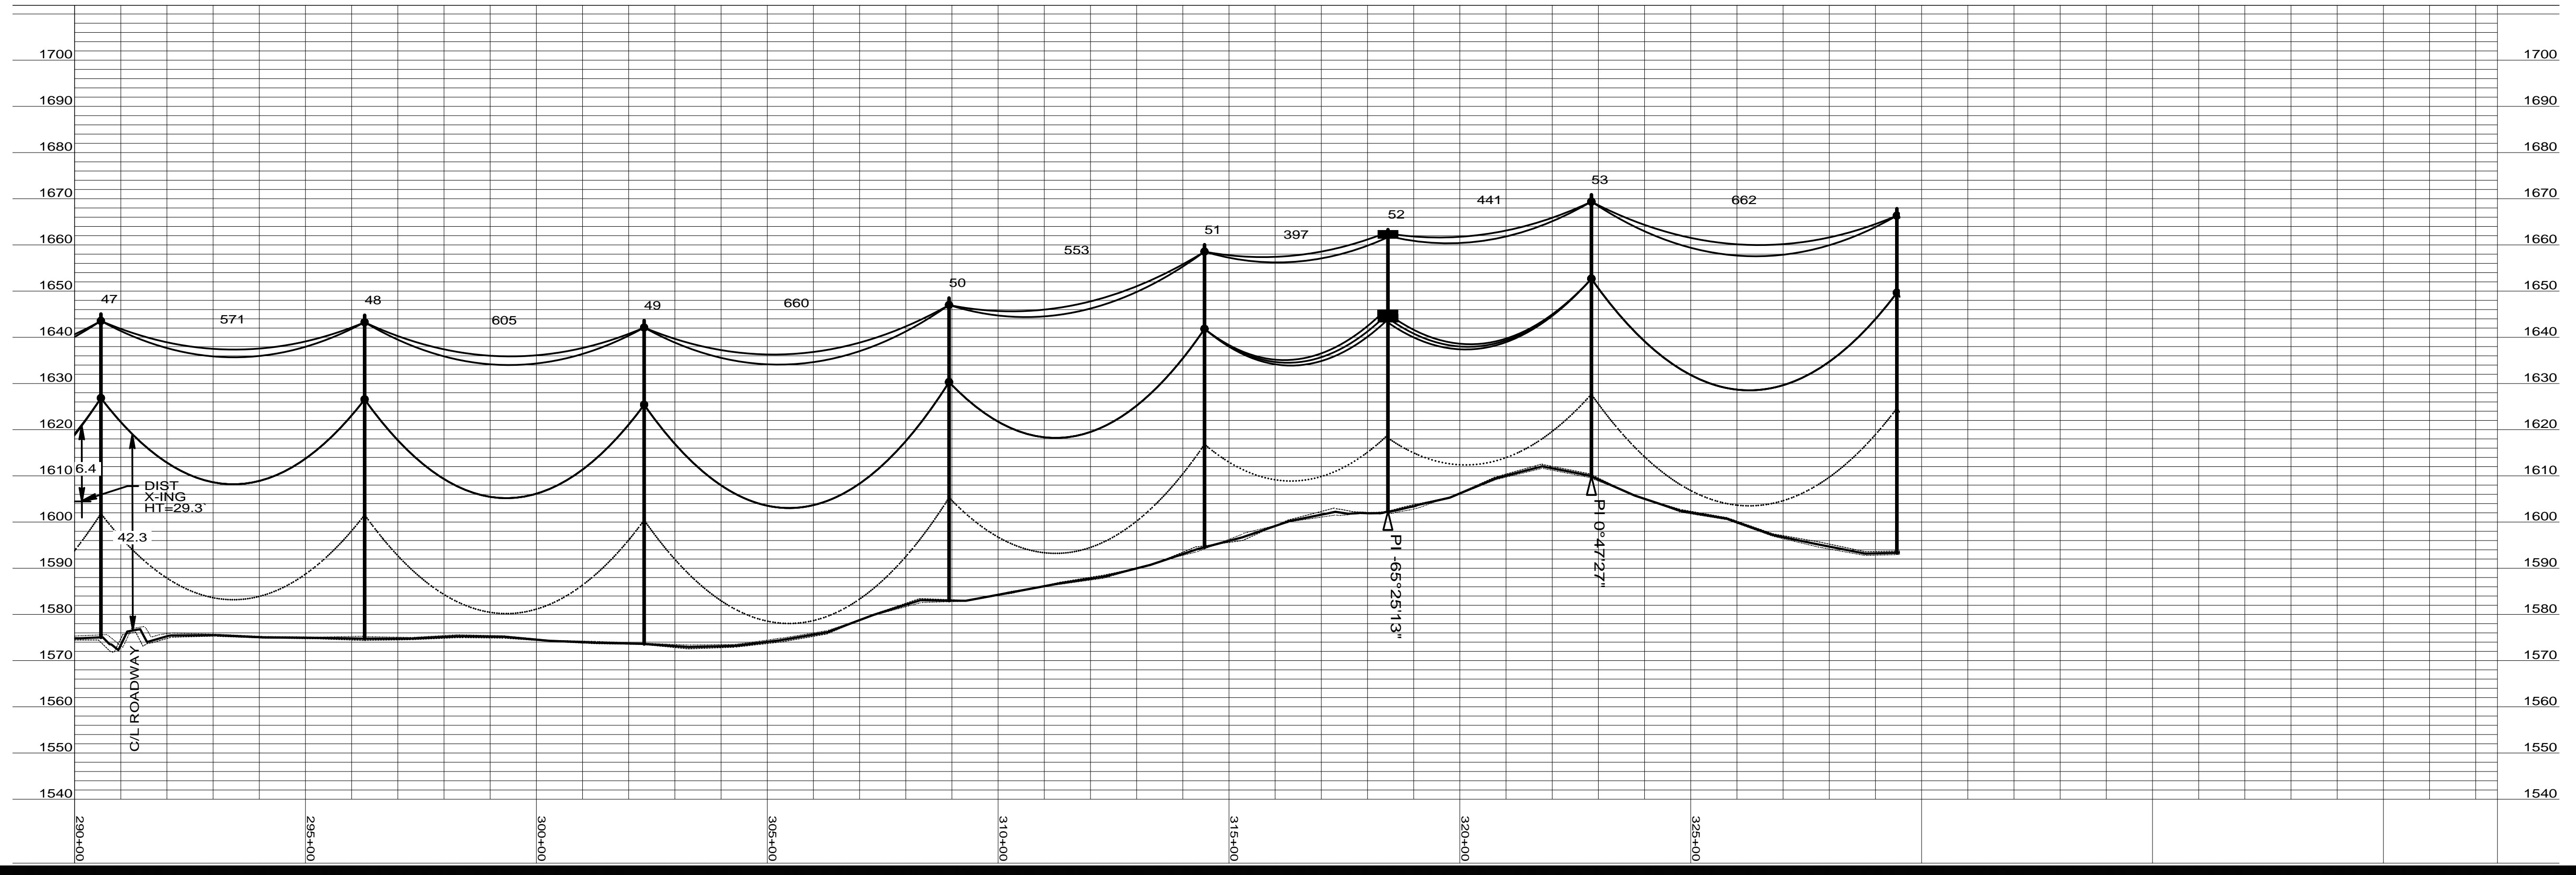

47 sta=290+57.02 2-80/2 HF-TAN GND DETAILS EMBED TM-16	48 sta=296+28.15 2-80/2 HF-TAN GND DETAILS EMBED TM-16	49 sta=302+33.50 2-80/2 HF-TAN GND DETAILS EMBED TM-16	50 sta=308+93.83 2-75/2 HF-TAN GND DETAILS EMBED TM-16	51 sta=314+47.04 2-75/2 HF-TAN GND DETAILS EMBED TM-16	52 sta=318+44.13 3-70/H1 3P-DE GND DETAILS EMBED TM-16 DAMPER (11)GUYING A,B,C	53 sta=322+84.87 2-70/2 HF-TAN GND DETAILS EMBED TM-16
--	--	--	--	--	--	--

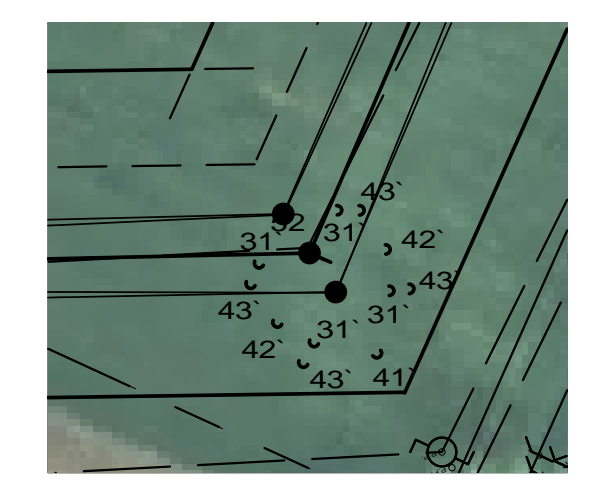

Bismarck-Denver-Detroit Lakes-Fargo-Minneapolis-Sioux Falls
 5201 East River Road, Suite 308
 Minneapolis, Minnesota 55421
 Phone: 763.571.2500 Fax: 763.571.1168
 Web: www.ulteig.com
 Drawn By: NGK
 Checked By: MPM
 Approved By: SPT

**RUGBY 230KV
 TRANSMISSION LINE
 PLAN AND PROFILE**

Project Number: 108_0495
 Date Created: December 3, 2008
 Dwg No: **RUG-E-515-07**