

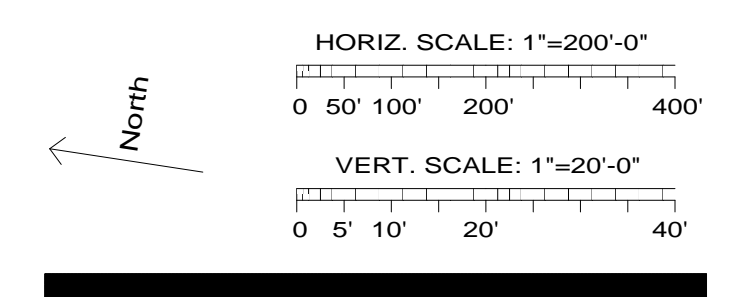


Rev	Date	By
0 - REVISED SINCE BID	03-04-09	SPT
1 - STR #82 & 83 MOVE	05-15-09	SPT
2 - RECORD DRAWING	04-16-10	

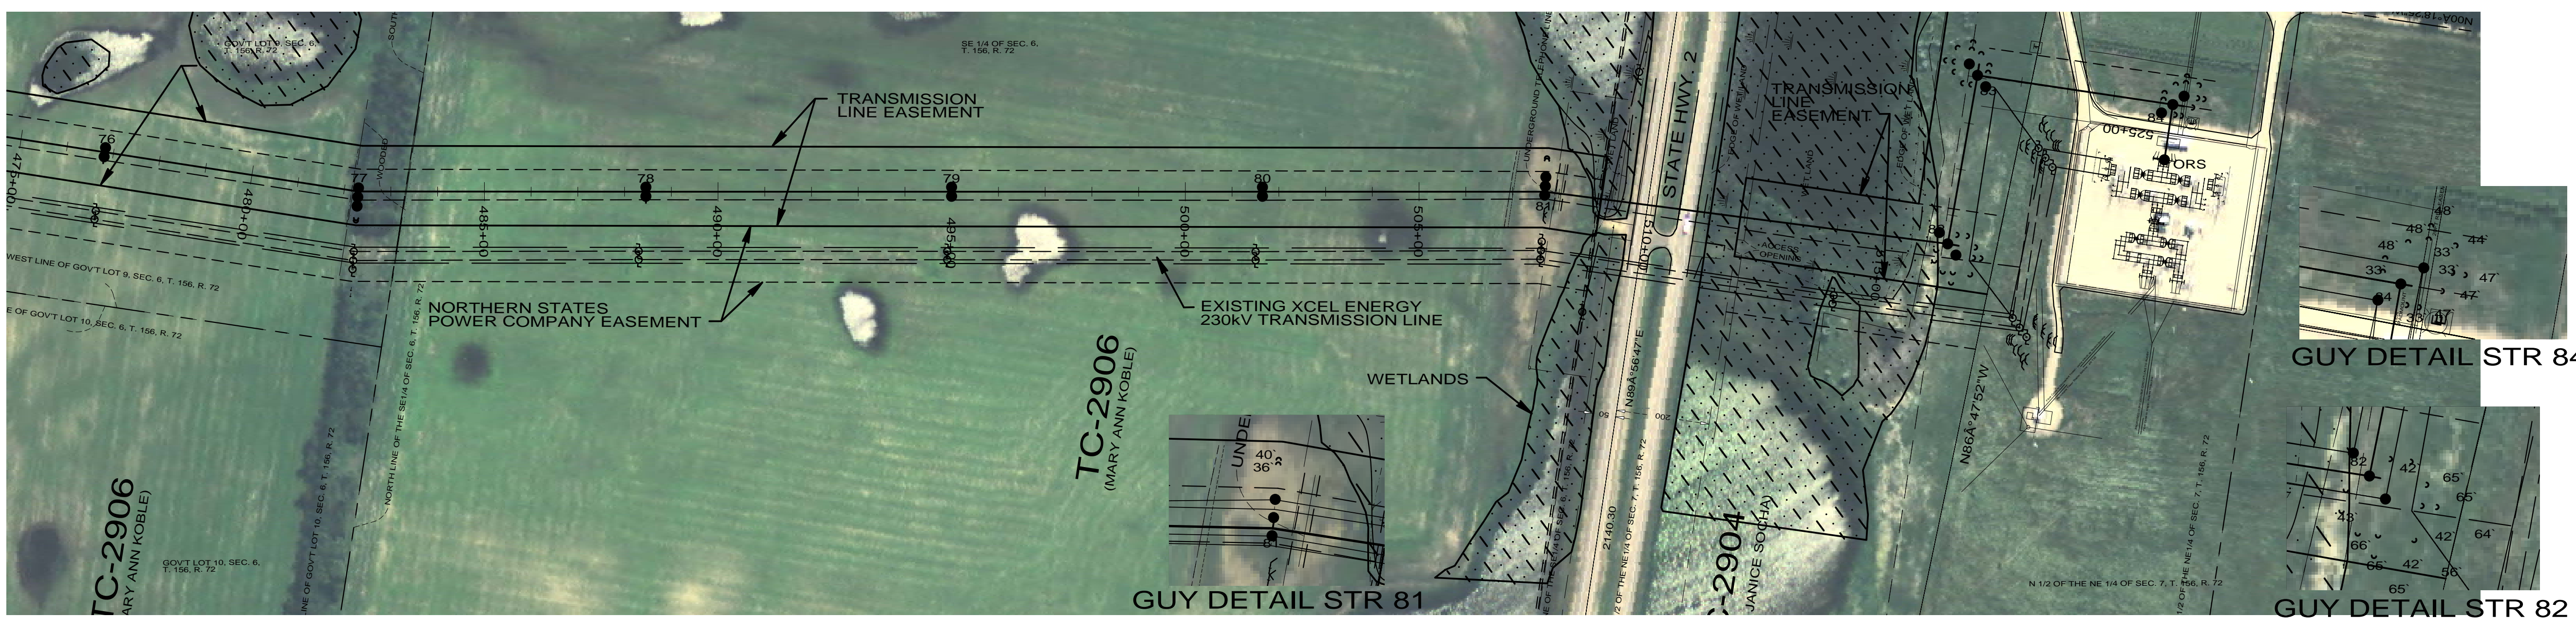

GUY DETAIL STR 84

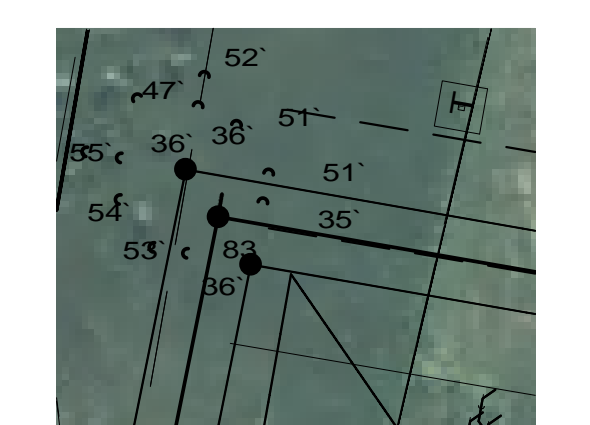


GUY DETAIL STR 83

GUY DETAIL STR 82

GUY DETAIL STR 81

76 sta=476+81.58 2-80'/2 HF-TAN GND DETAILS EMBED TM-16	77 sta=482+30.12 3-80'/2 3P-SM-ANG GND DETAILS EMBED TM-16 (2)GUYING A,B,C	78 sta=488+45.73 2-75'/2 HF-TAN GND DETAILS EMBED, (2)CULVERTS TM-16	79 sta=494+99.89 2-80'/2 HF-TAN GND DETAILS EMBED, (2)CULVERTS TM-16	80 sta=501+65.08 2-80'/2 HF-TAN GND DETAILS EMBED, (2)CULVERTS TM-16	81 sta=507+69.44 3-100'/1 3P-SM-ANG GND DETAILS EMBED TM-16 (2)GUYING A,B,C	82 sta=516+38.31 3-95'/H1 3P-DE GND DETAILS EMBED, (3)CULVERTS TM-16 DAMPER (1)GUYING A,B,C	83 sta=520+04.47 3-30'/H1 3P-DE GND DETAILS EMBED TM-16 DAMPER (1)GUYING A,B,C	84 sta=524+27.04 3-75'/H1 3P-DE GND DETAILS EMBED TM-16 DAMPER (1)GUYING A,B,C	ORS sta=525+46.69 RUG-OTI-SUB OPGW-S
---	---	--	--	--	--	---	--	--	---

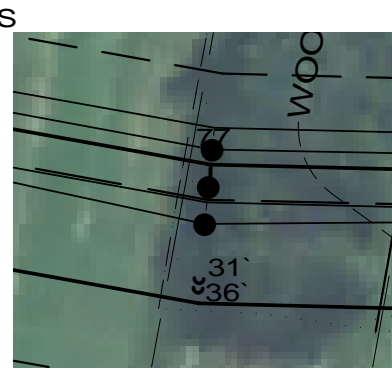

GUY DETAIL STR 77



Bismarck-Denver-Detroit Lakes-Fargo-Minneapolis-Sioux Falls  
 5201 East River Road, Suite 308  
 Minneapolis, Minnesota 55421  
 Phone: 763.571.2500 Fax: 763.571.1168  
 Web: www.ulteig.com  
 Drawn By: NGK  
 Checked By: MPM  
 Approved By: SPT

**RUGBY 230kV  
 TRANSMISSION LINE  
 PLAN AND PROFILE**

Project Number: 108\_0495  
 Date Created: December 3, 2008  
 Dwg No: **RUG-E-515-011**