



10" TO MAINLINE PUMP

 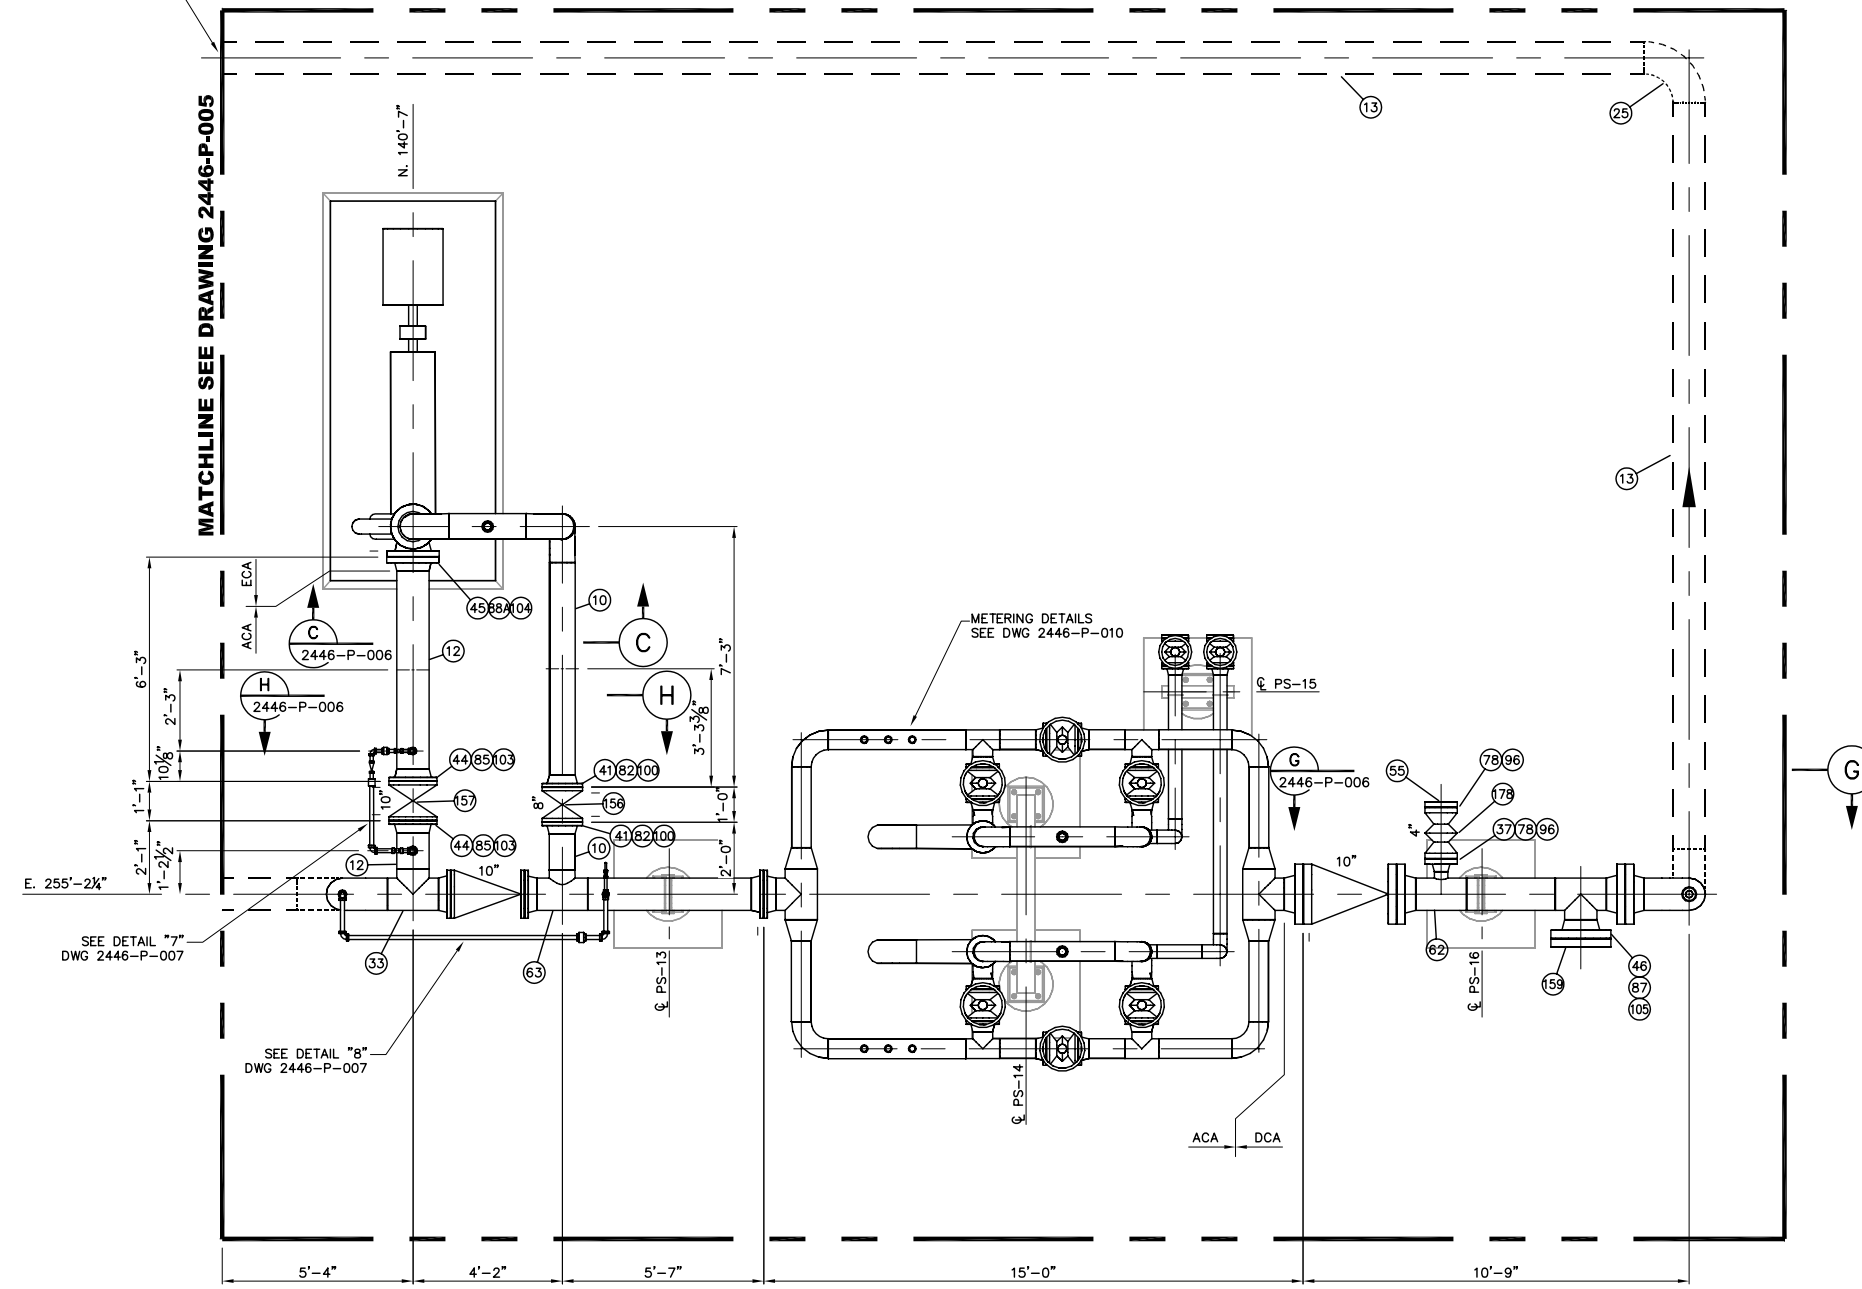


NO	REVISION	DATE	APPR	BY
1	AS-BUILT	2/12/08		
0	ISSUED FOR CONSTRUCTION	4/20/07		


TRENTON (ND) STATION
 PIPING PLAN
 BOOSTER PUMP & METERING

PROJECT:	SCALE: 3/8"=1'-0"	DATE: 10/3/06	DRAWN: ADJ
CHECK:	APPR:	DATE:	

DWG. NO. 2446-P-004


Rooney Engineering, Inc.
 12201 E. Arapahoe Rd.
 Centennial, CO 80112
 (303) 792-5911