


PLAN
SCALE 3/8"=1'-0"

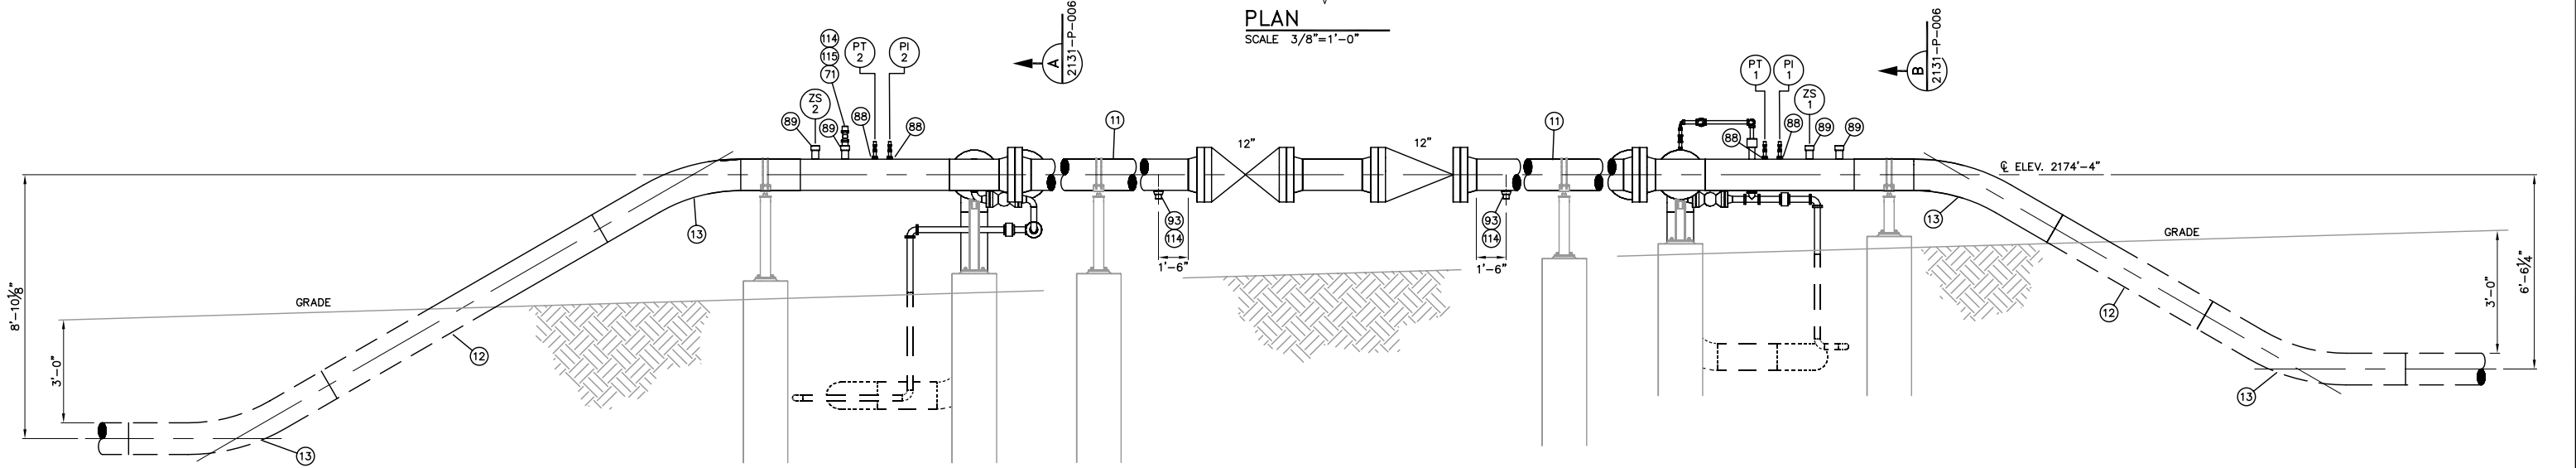

ELEVATION
SCALE 3/8"=1'-0"

NO	REVISION	DATE	APPR	BY
1	AS-BUILT	2/7/08	EJK	ADJ
0	ISSUED FOR CONSTRUCTION	4/30/07	EJK	ADJ

ENBRIDGE PIPELINES (ND)

BLAISDELL STATION

STATION MANIFOLD
PIPING PLAN

Rooney Engineering, Inc.
12201 E. Arapahoe Rd.
Centennial, CO 80112
(303) 792-5911

PROJECT:

SCALE: AS NOTED	DATE: 12/18/06	DRAWN: ADJ
CHECK: EJK	APPR:	DATE:

DWG. NO. 2431-P-003