
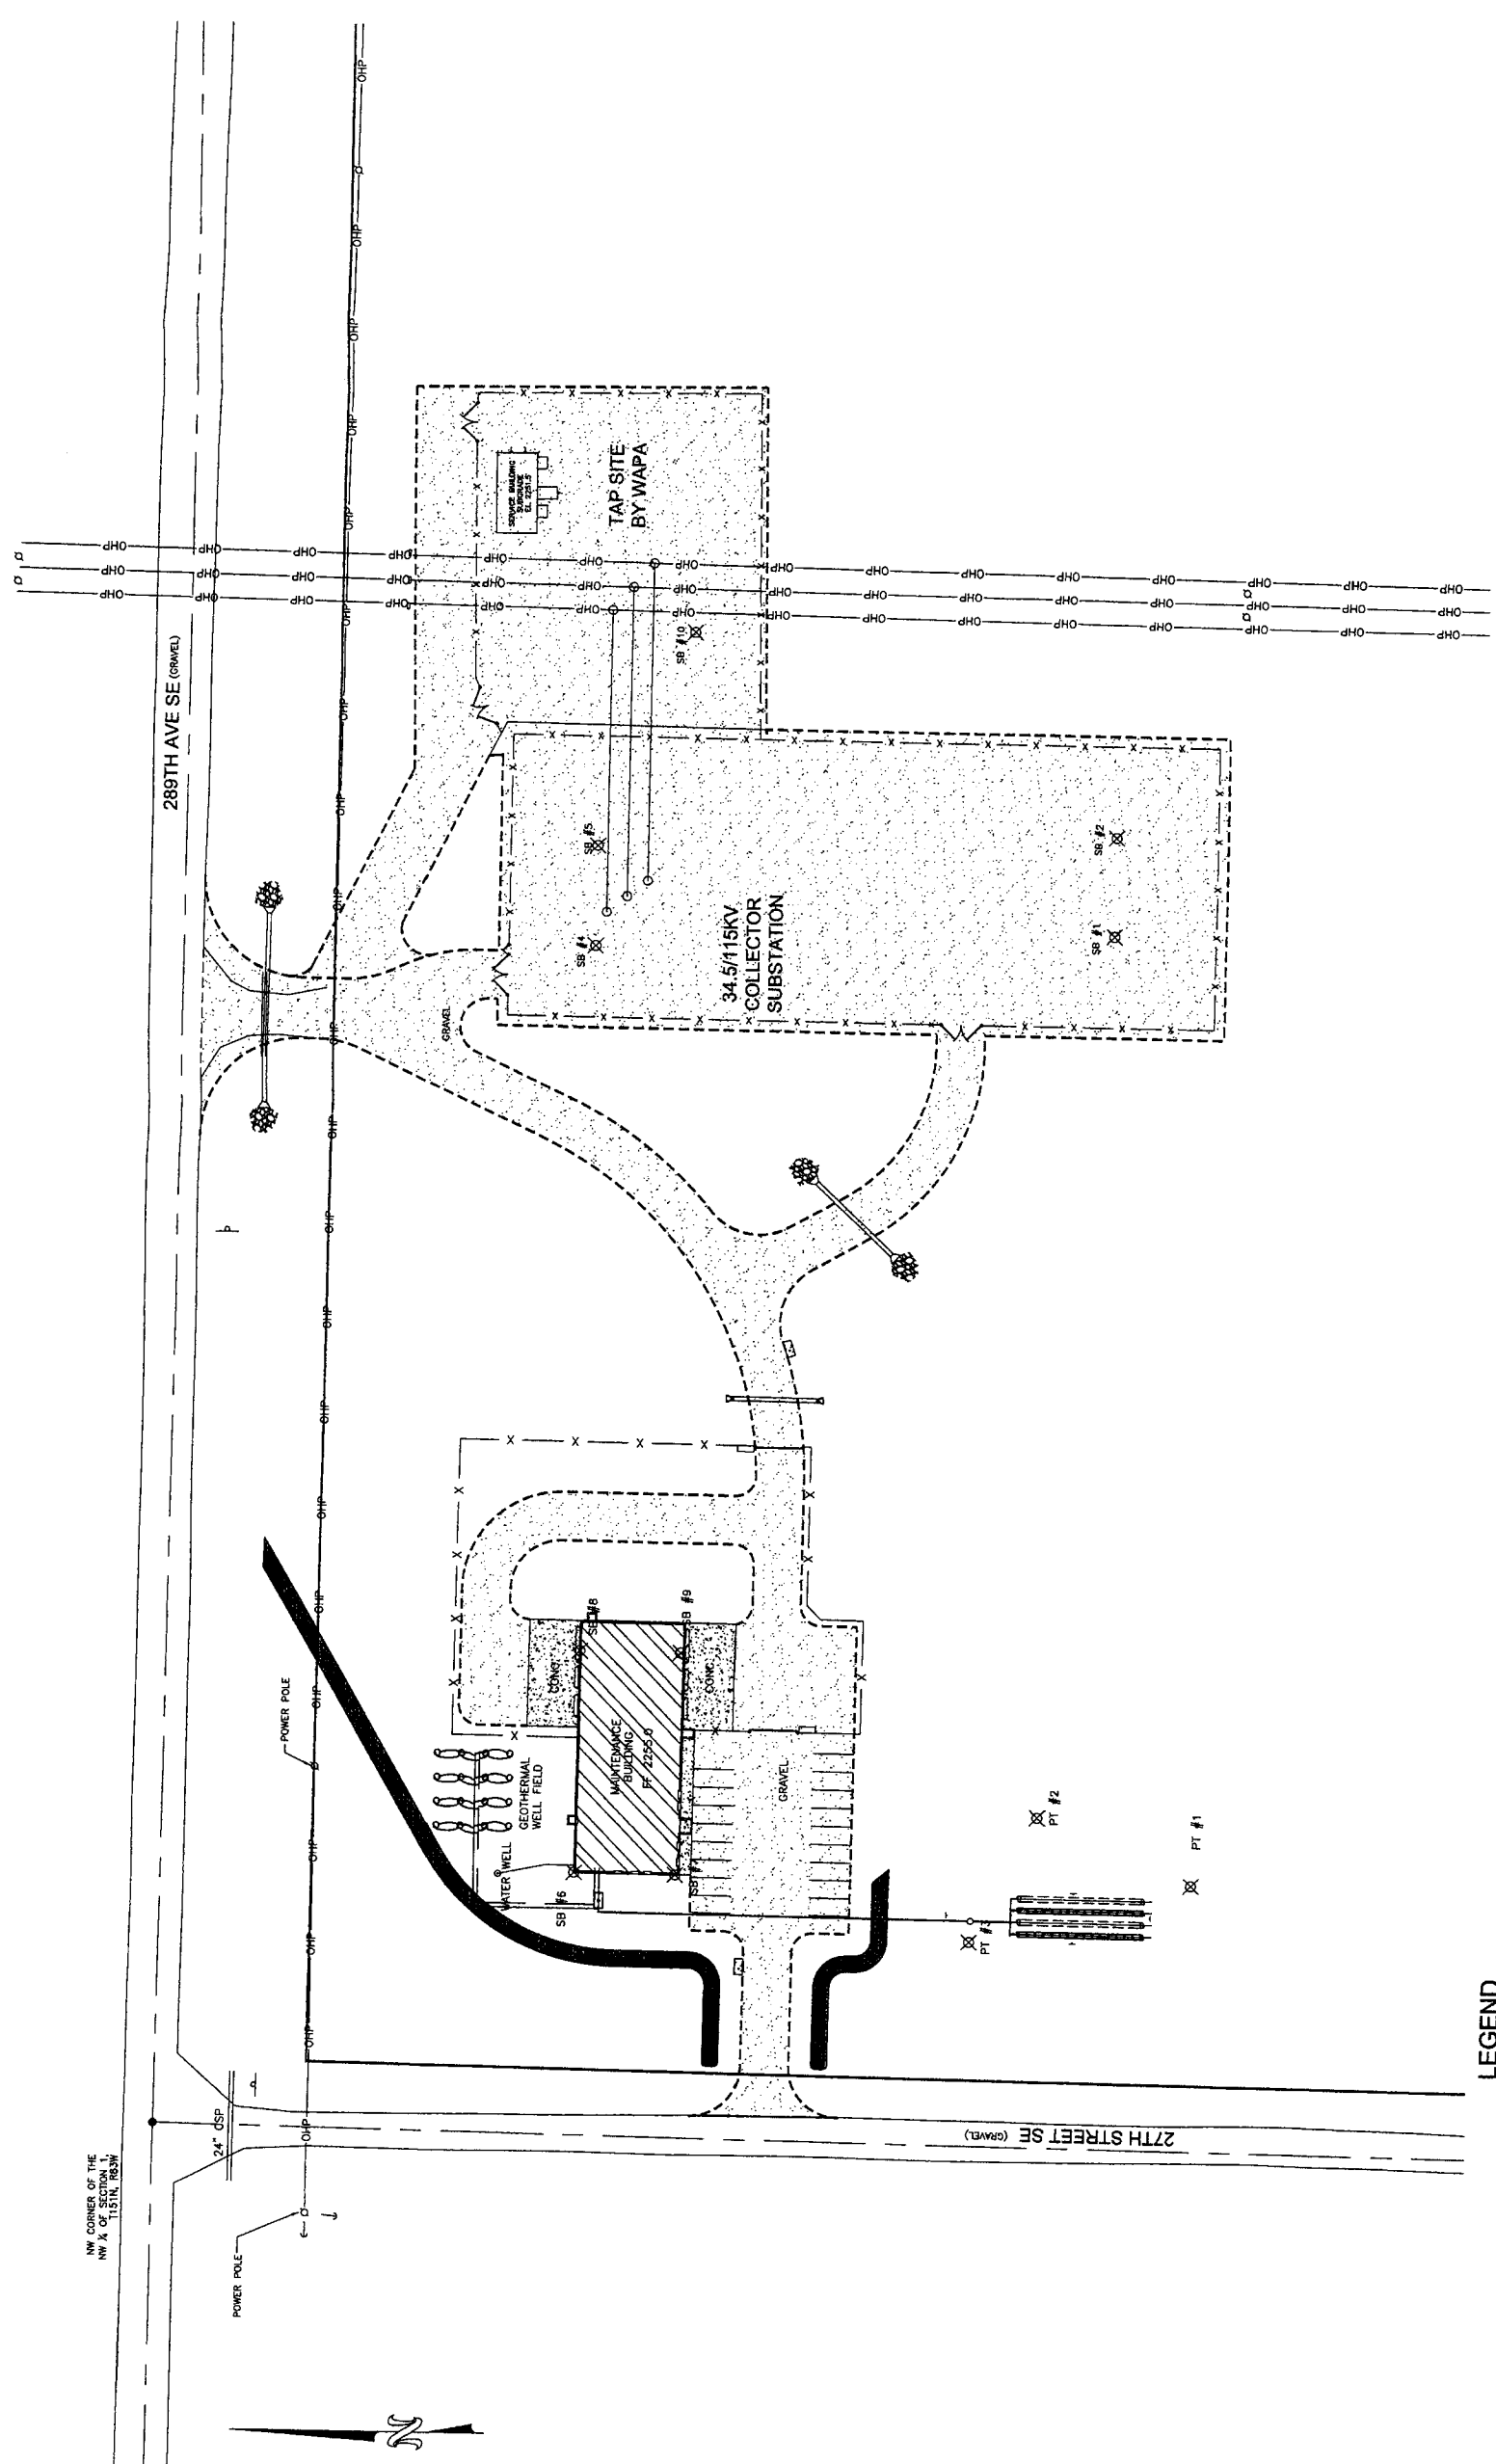


**EXHIBIT**  
7

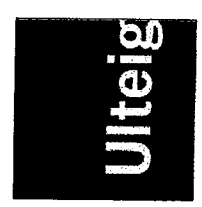

PROJECT: TRANSMISSION SYSTEM MAINTENANCE LOCATION: 399 - 34.5/115KV PRAIRIEWINDS 1 COLLECTOR SUBSTATION CONTRACT/ASSIGNMENT:		DESIGN BY: J. VELLA DRAWN BY: L. GODDARD DATE OK: 1/24/09 APPROVED: [Signature] SCALE: 1" = 40' VENDOR/OBNOBVED FROM: ULTEIG VENDOR DRAWING NO.: ORIGINAL REV:
REFERENCE DRAWINGS:		SITE PLAN BASIN ELECTRIC POWER COOPERATIVE 1500 N. W. 10TH AVENUE, SUITE 200 DENVER, CO 80202 PHONE: 701-233-0441

REV.	DESCRIPTION	DATE	APPD	DATE
B	UPDATE SITE LAYOUT	4/7/09	E. HUELLE	4/7/09
A	PRELIMINARY	1/19/09	E. HUELLE	1/19/09

**LEGEND**

--- (dashed line)	SECTION LINE	⊗ (circle with cross)	SOIL BORING
--- (dash-dot line)	PROPERTY LINE	⊗ (circle with cross)	SIGN
— (solid line)	OVERHEAD POWERLINES	▨ (hatched area)	PROPOSED GRAVEL SURFACE
⊙ (circle)	UTILITY POLE	- - - (dashed line)	PROPOSED GRAVEL EDGE
— (solid line)		- - - - - (dash-dot-dot line)	PROPOSED FENCE