



# ROONEY ENGINEERING, INC

12201 East Arapahoe Road, C-10, Centennial, CO 80112  
(303) 792-5911

RECEIVED

MAR 23 2011

## DOCUMENT TRANSMITTAL SHEET PUBLIC SERVICE COMMISSION

**PROJECT NAME:** Phase 6 Expansion – Alexander Station & Stanley Tank

**TRANSMITTAL DATE:** March 22, 2011

**TRANSMITTAL NUMBER:** 2534-032111-01 – As-Built for Orders PU-07-791 and Alexander Station PU-10-33

**TRANSMITTAL TO:** **ATTN: Patrick Fahn**  
Director - Compliance and Competitive Markets  
North Dakota Public Service Commission  
600 E. Boulevard  
Bismarck, ND 58505-0480

**CC:** **Enbridge Pipeline (ND) LLC:** Brent Horton (w/CD), Sally Joyce, (w/CD), Trent Mattick, Steve Schmaltz, Tony Kueffler, Gary Blowers, Claudia Schrull

**Rooney Engineering Inc.:** Troy Pierantoni (w/CD), Ty France, Ed Kelly, Scott Frank, Eric Stahl

**PHONE NUMBER:** 701-328-4077


**TRANSMITTED VIA:** FedEx


**TRANSMITTAL FROM:** Jill Sanchez

**Enclosed are: CD COPIES OF ALEXANDER STATION AS-BUILTS FOR ORDERS PU-07-791 AND PU-10-33. (PDF and CAD format)**

**Hard Copy:**

**534-P-01000 – Alexander Station ND PSC Submittal Plot Plan Rev. 1 (2-24-11)**  
**609-P-05001 – Stanley Station ND PSC Submittal Plot Plan Rev. 1 (2-24-11)**


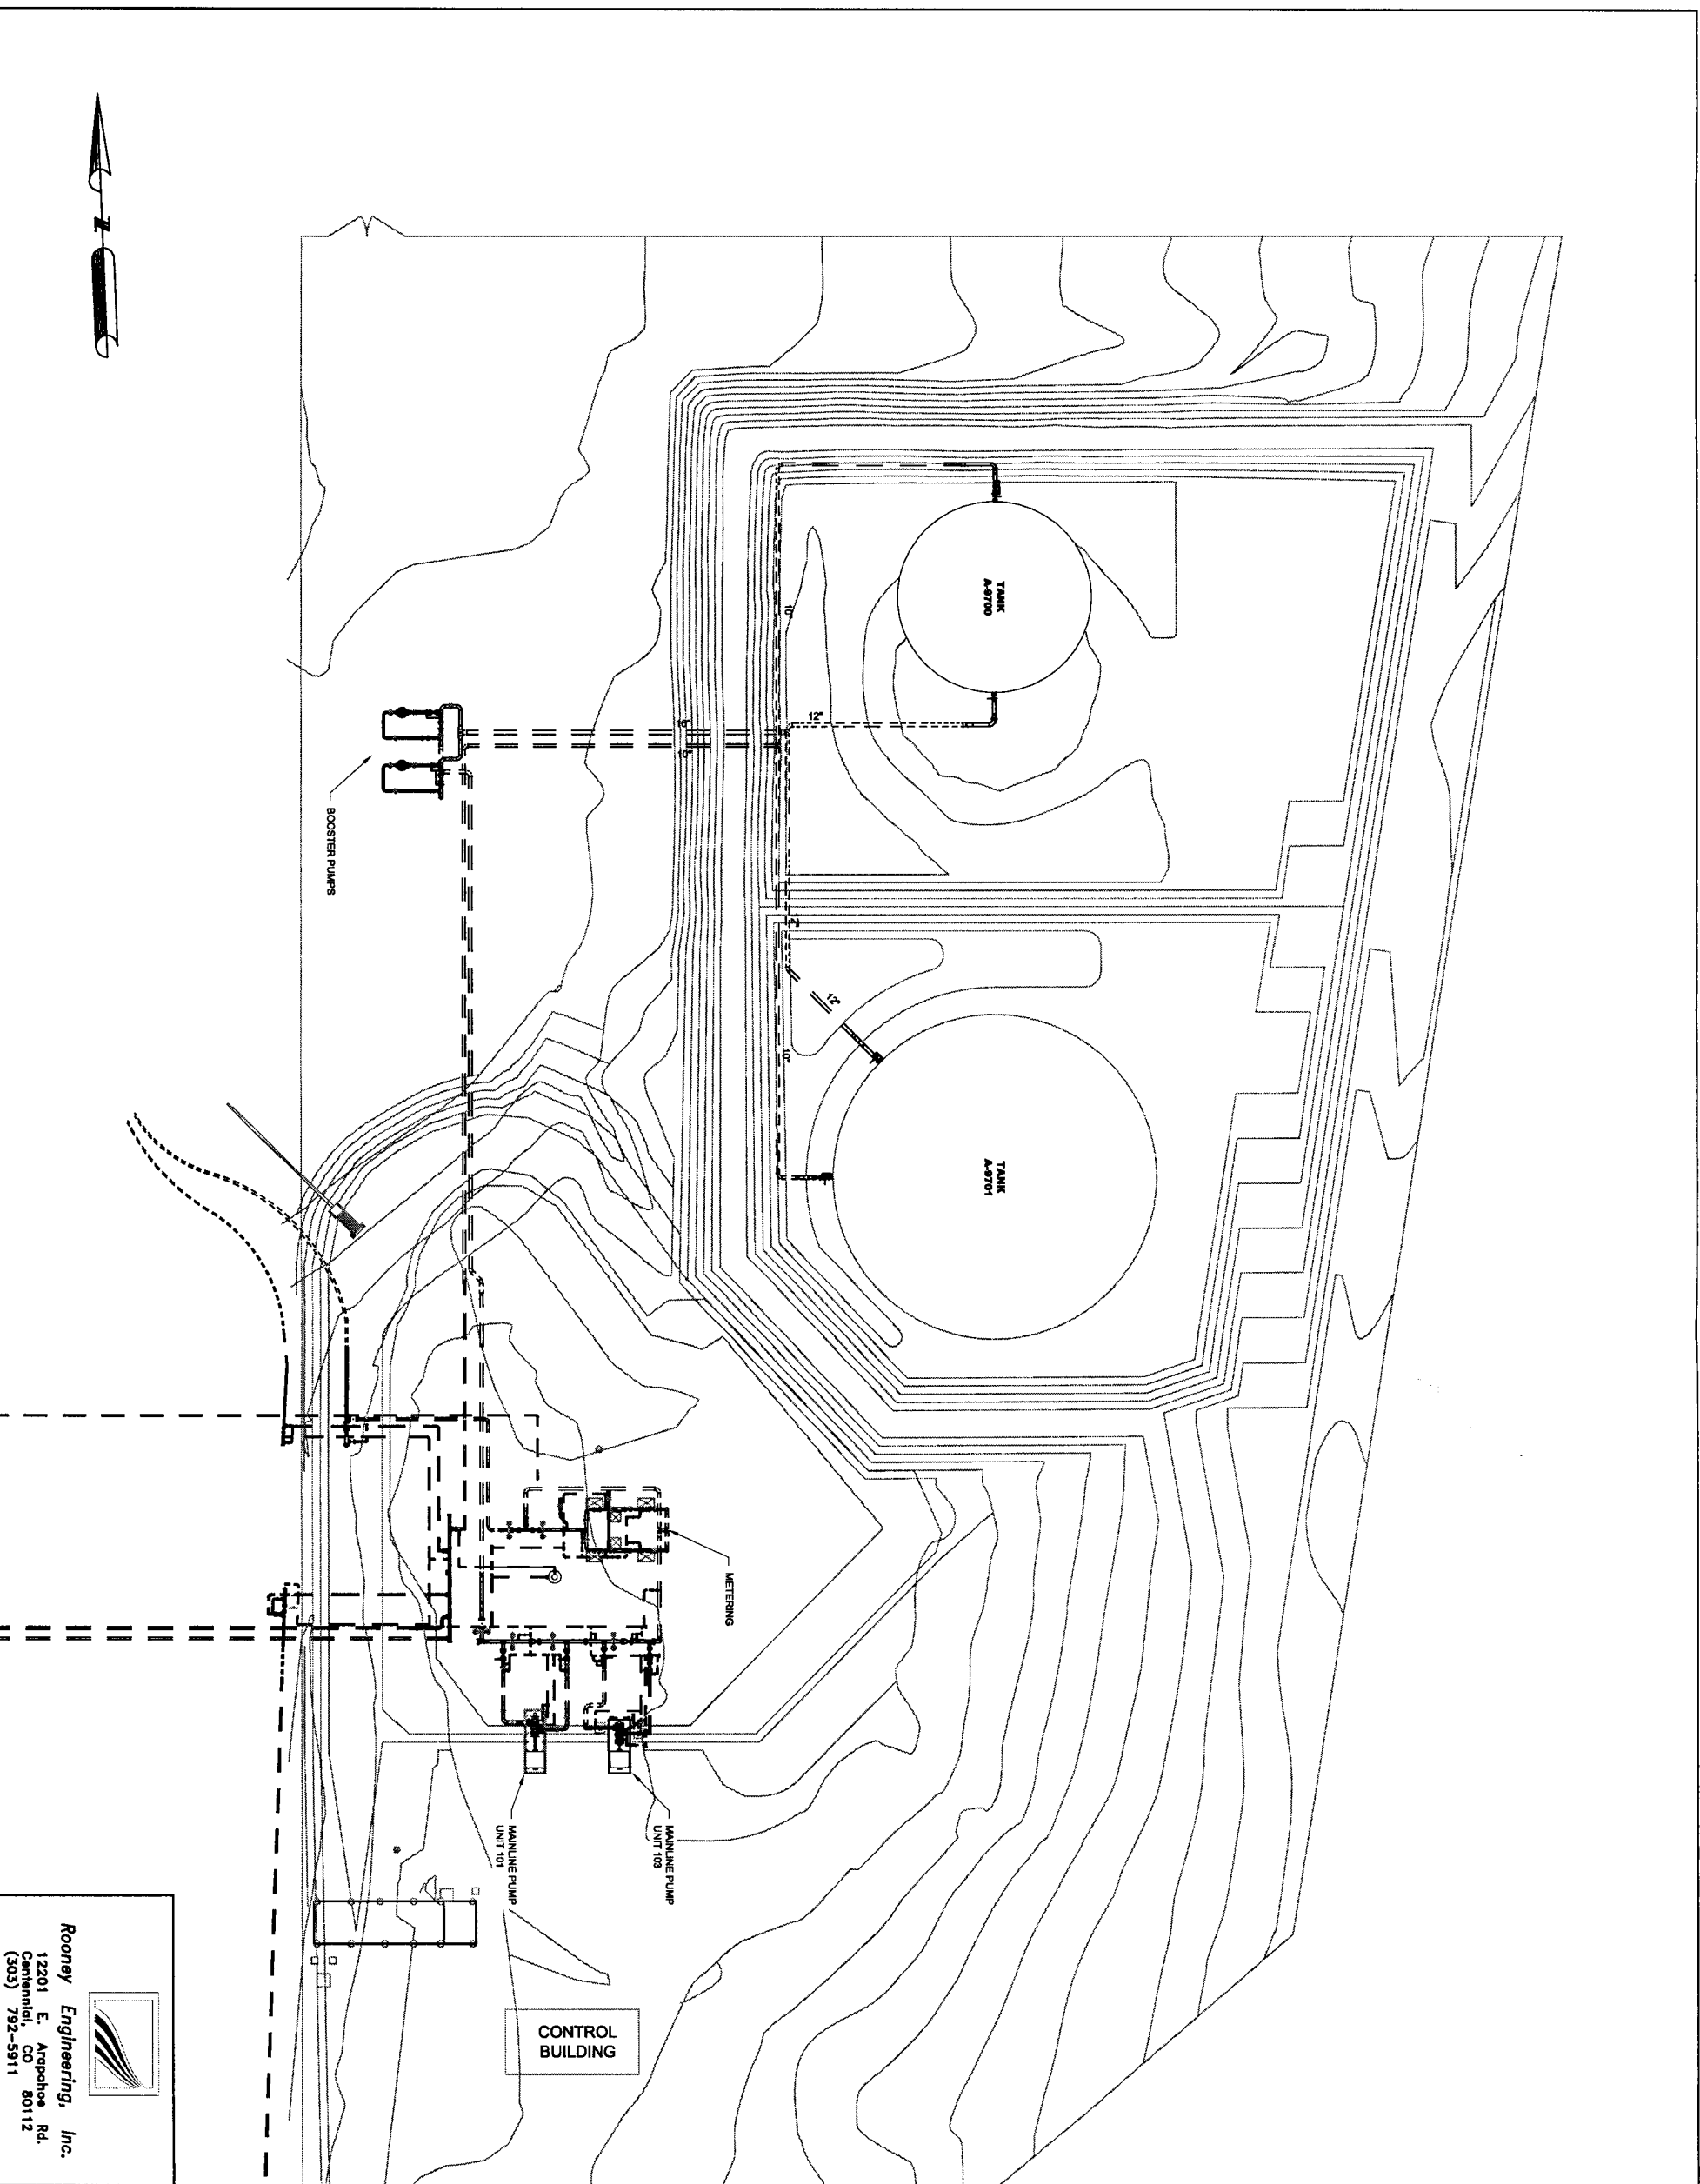



  
**Rooney Engineering, Inc.**  
 12201 E. Arapahoe Rd.  
 Centennial, CO 80112  
 (303) 792-5911

NO	REVISION	DATE	APPR	BY
1	ISSUED FOR AS-BUILT	2/24/11	SHF	MV
0	ISSUED FOR CONSTRUCTION	8/10/10	SHF	ADJ
NO	REVISION	DATE	APPR	BY


  
**ENBRIDGE PIPELINES (NORTH DAKOTA) LLC**  
**ALEXANDER (ND) STATION**  
 ND PSC SUBMITTAL  
 PLOT PLAN

 PROJECT: \_\_\_\_\_  
 SCALE: 3/32"=1'-0"    DATE: 4/28/08    DRAWN: ADJ  
 CHECK: \_\_\_\_\_    APPR: \_\_\_\_\_    DATE: \_\_\_\_\_  
**DWG. NO. 534-P-01000**

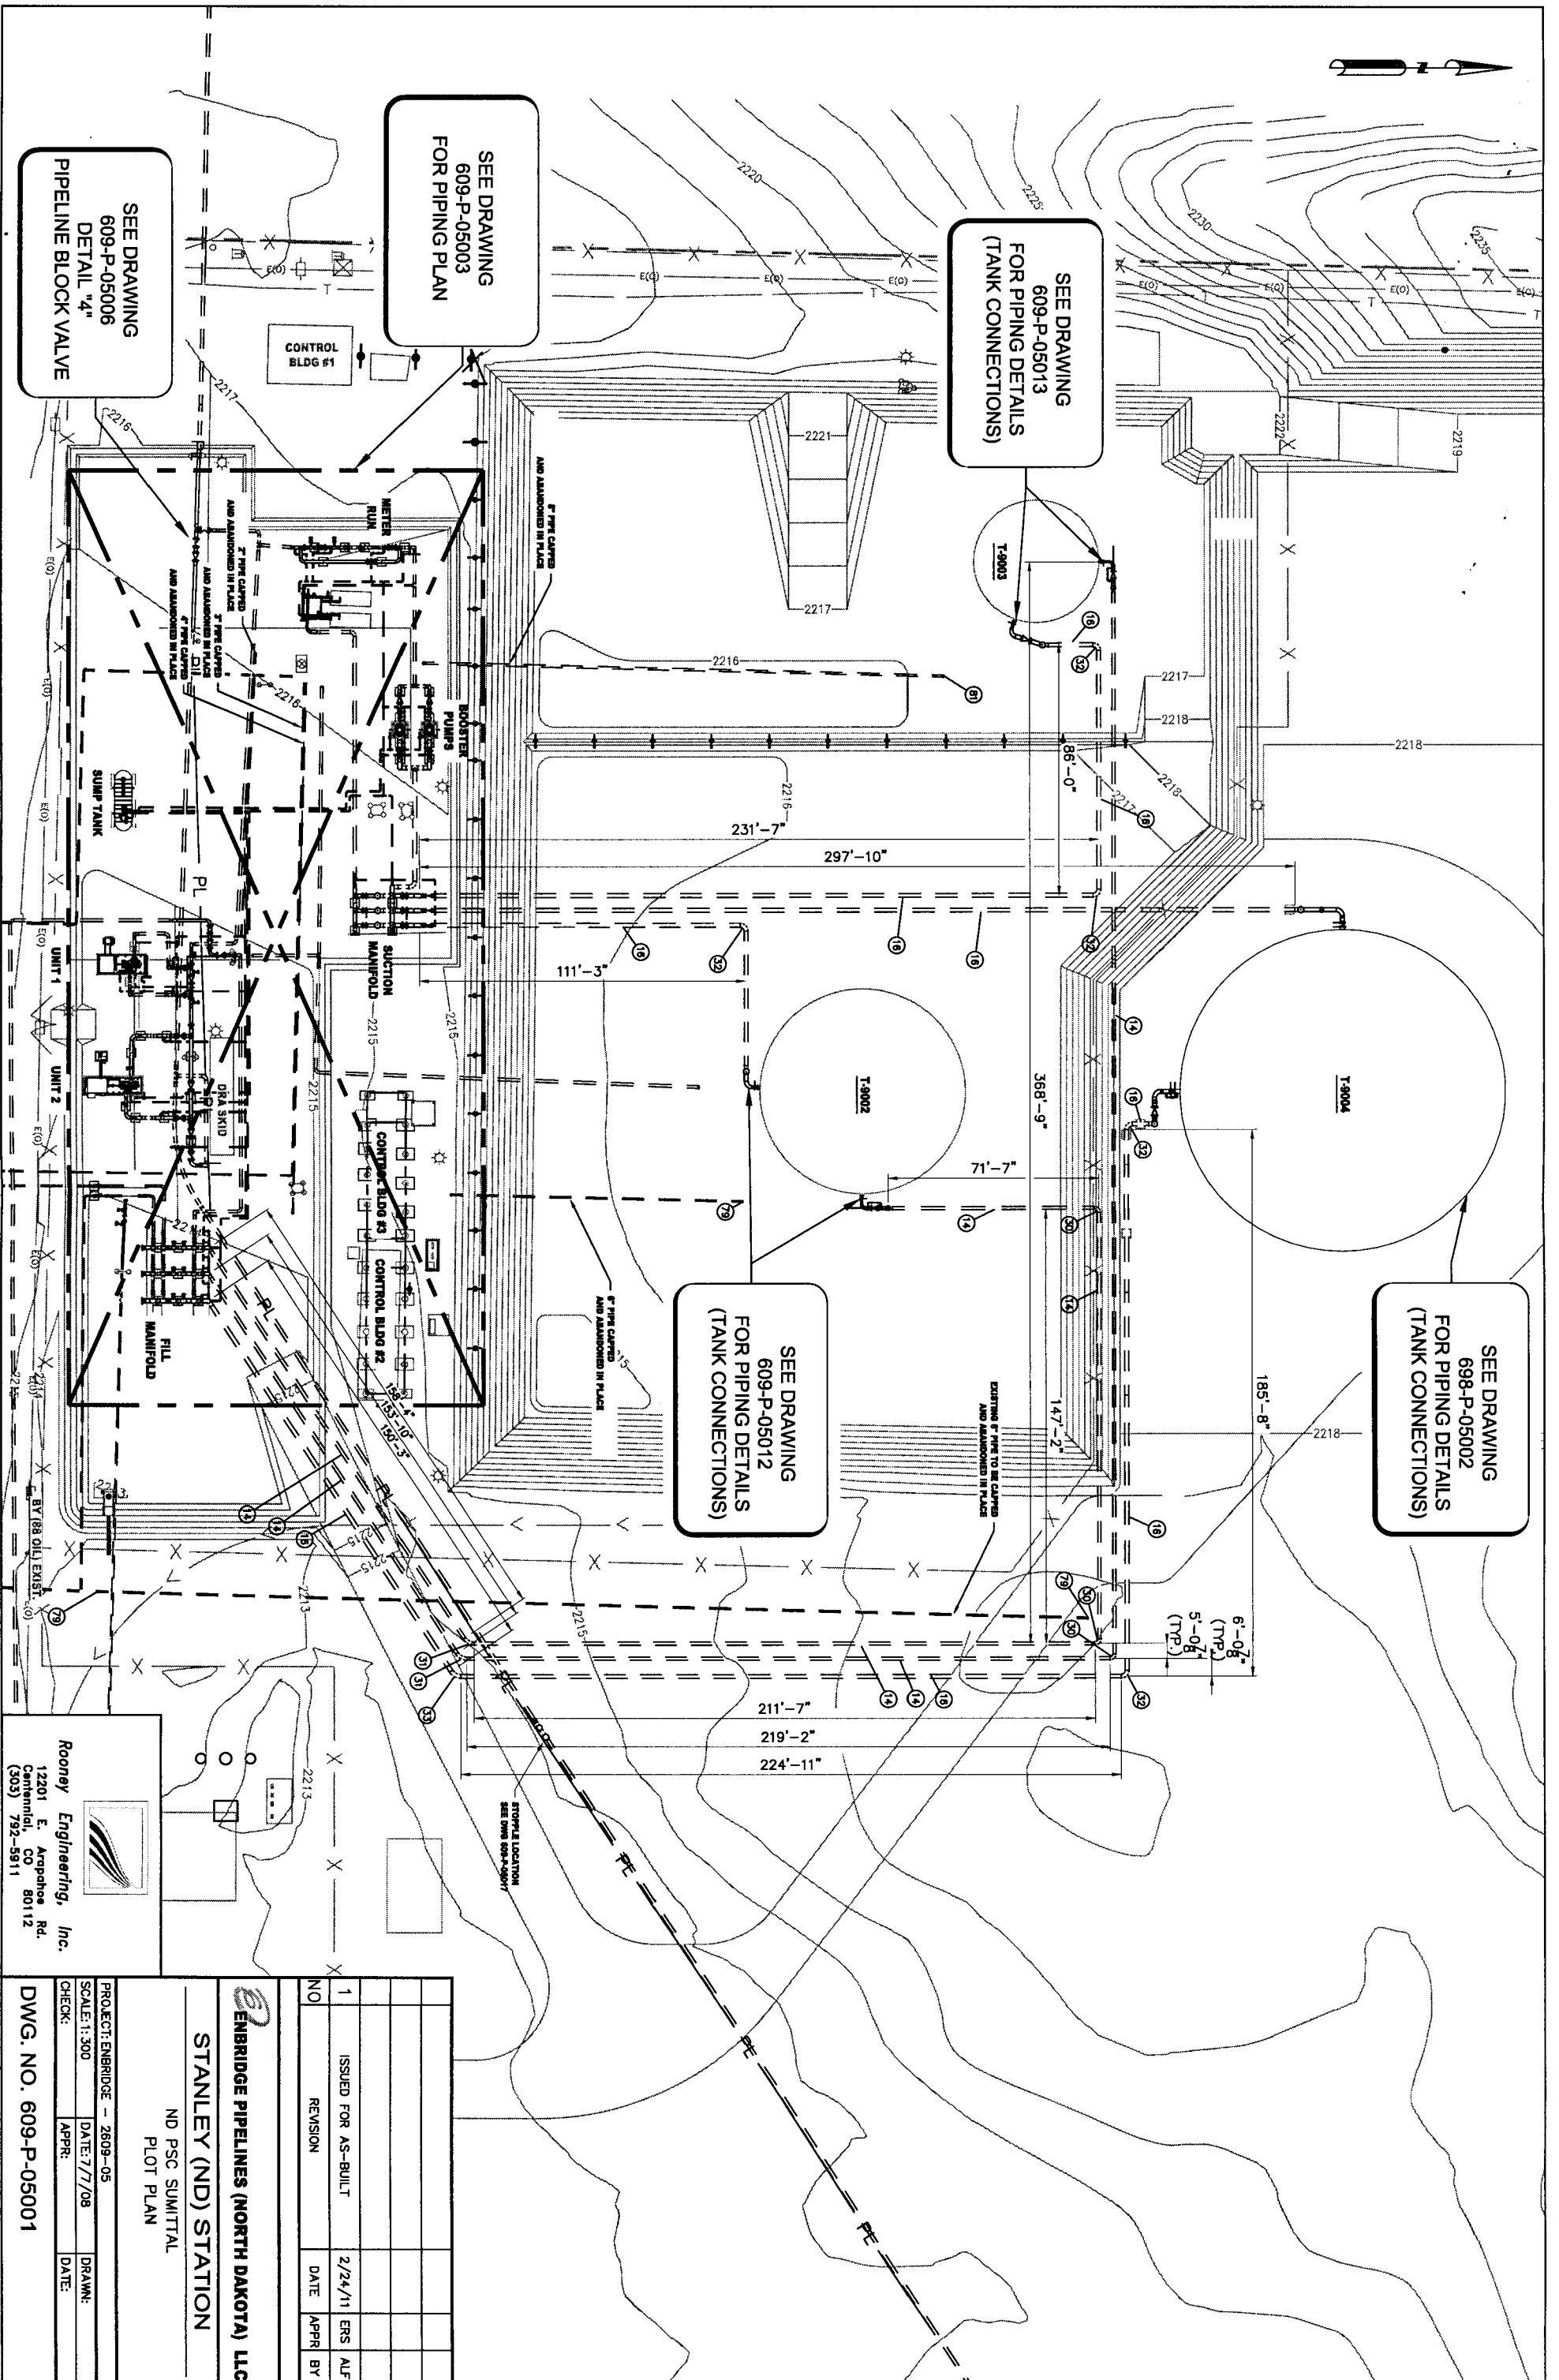

SEE DRAWING  
698-P-05002  
FOR PIPING DETAILS  
(TANK CONNECTIONS)

SEE DRAWING  
609-P-05013  
FOR PIPING DETAILS  
(TANK CONNECTIONS)

SEE DRAWING  
609-P-05012  
FOR PIPING DETAILS  
(TANK CONNECTIONS)

SEE DRAWING  
609-P-05003  
FOR PIPING PLAN

SEE DRAWING  
609-P-05006  
DETAIL "4"  
PIPELINE BLOCK VALVE

**Rooney Engineering, Inc.**  
12201 E. Arapahoe Rd.  
Centennial, CO 80112  
(303) 792-5811

<b>ENBRIDGE PIPELINES (NORTH DAKOTA) LLC</b> STANLEY (ND) STATION ND PSC SUBMITTAL PLOT PLAN				
PROJECT: ENBRIDGE - 2809-05	DATE: 7/7/08	DRAWN:		
SCALE: 1:300	DATE: 7/7/08	DATE:		
CHECK:	APPR:	DATE:		
<b>DWG. NO. 609-P-05001</b>				
NO	ISSUED FOR AS-BUILT	2/24/11	ERS	ALF
1	REVISION	DATE	APPR	BY