

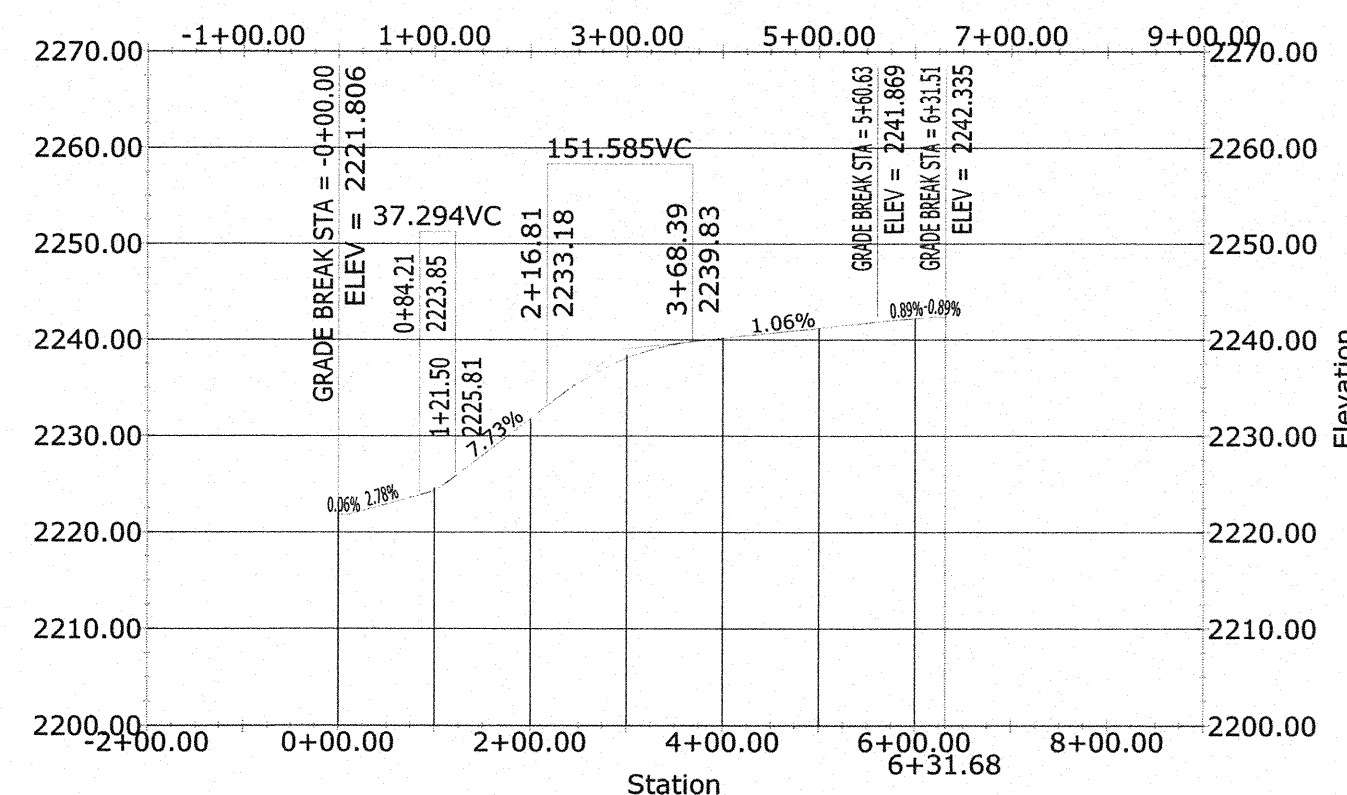


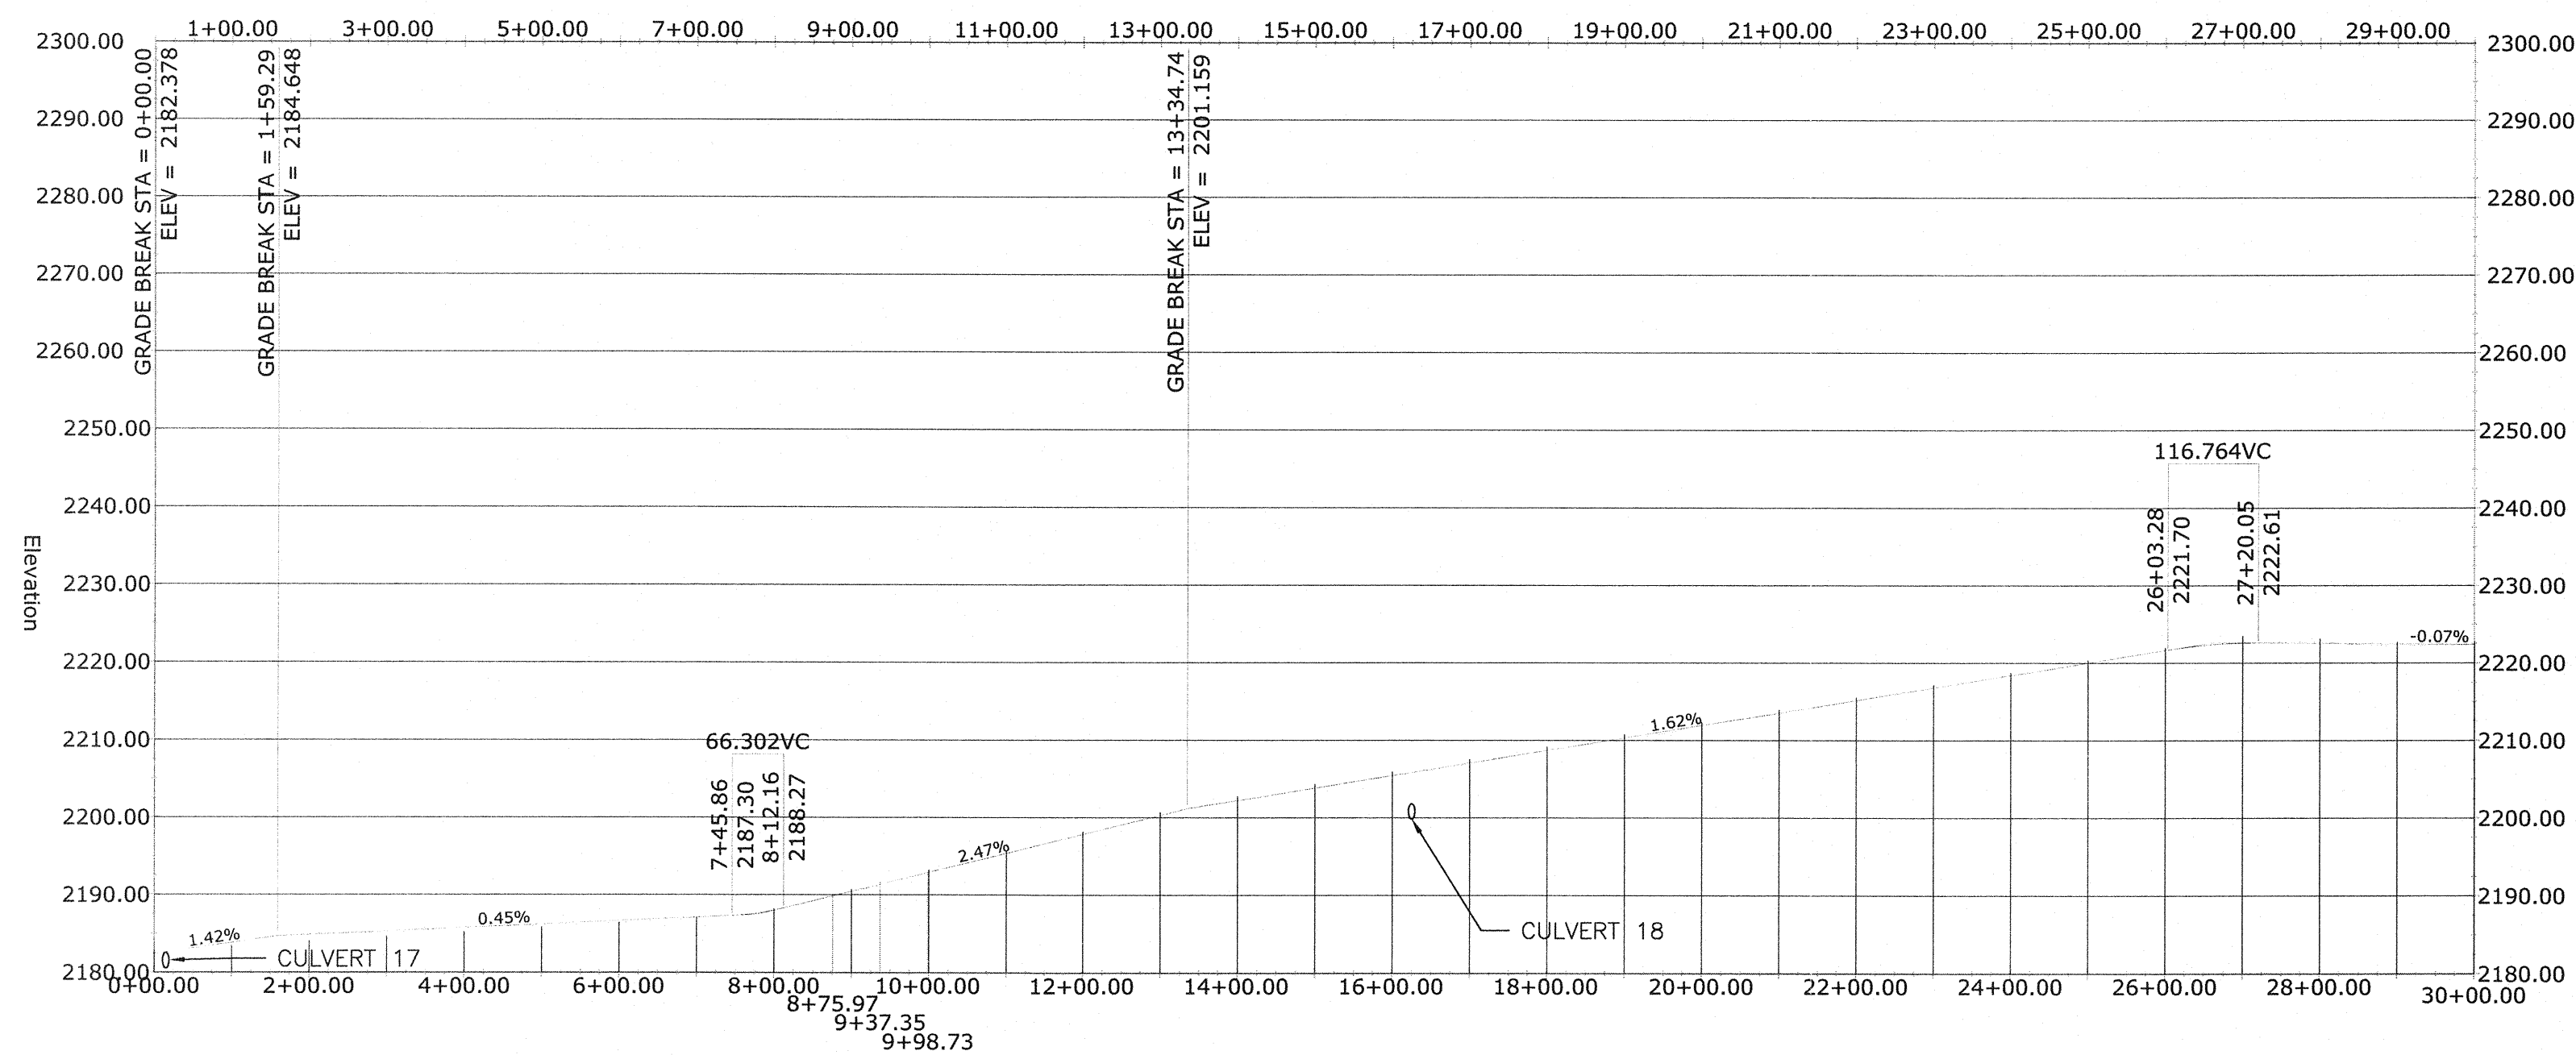

EXTERNAL REFERENCE:
 • 34301006-BASE-C3D-DESIGN-ROADS-BISON 3-AS BUILT.DWG

A	KKB	CAD	JXB	07/15/11	60 PERCENT SUBMITTAL
B	CAD	CAD	JXB	09/02/11	90 PERCENT SUBMITTAL
C	CAD	CAD	JXB	09/30/11	ISSUED FOR CONSTRUCTION
1	NJC			1/7/13	CONSTRUCTION REVISIONS
NO.	BY	CHK.	APP.	DATE	REVISION DESCRIPTION

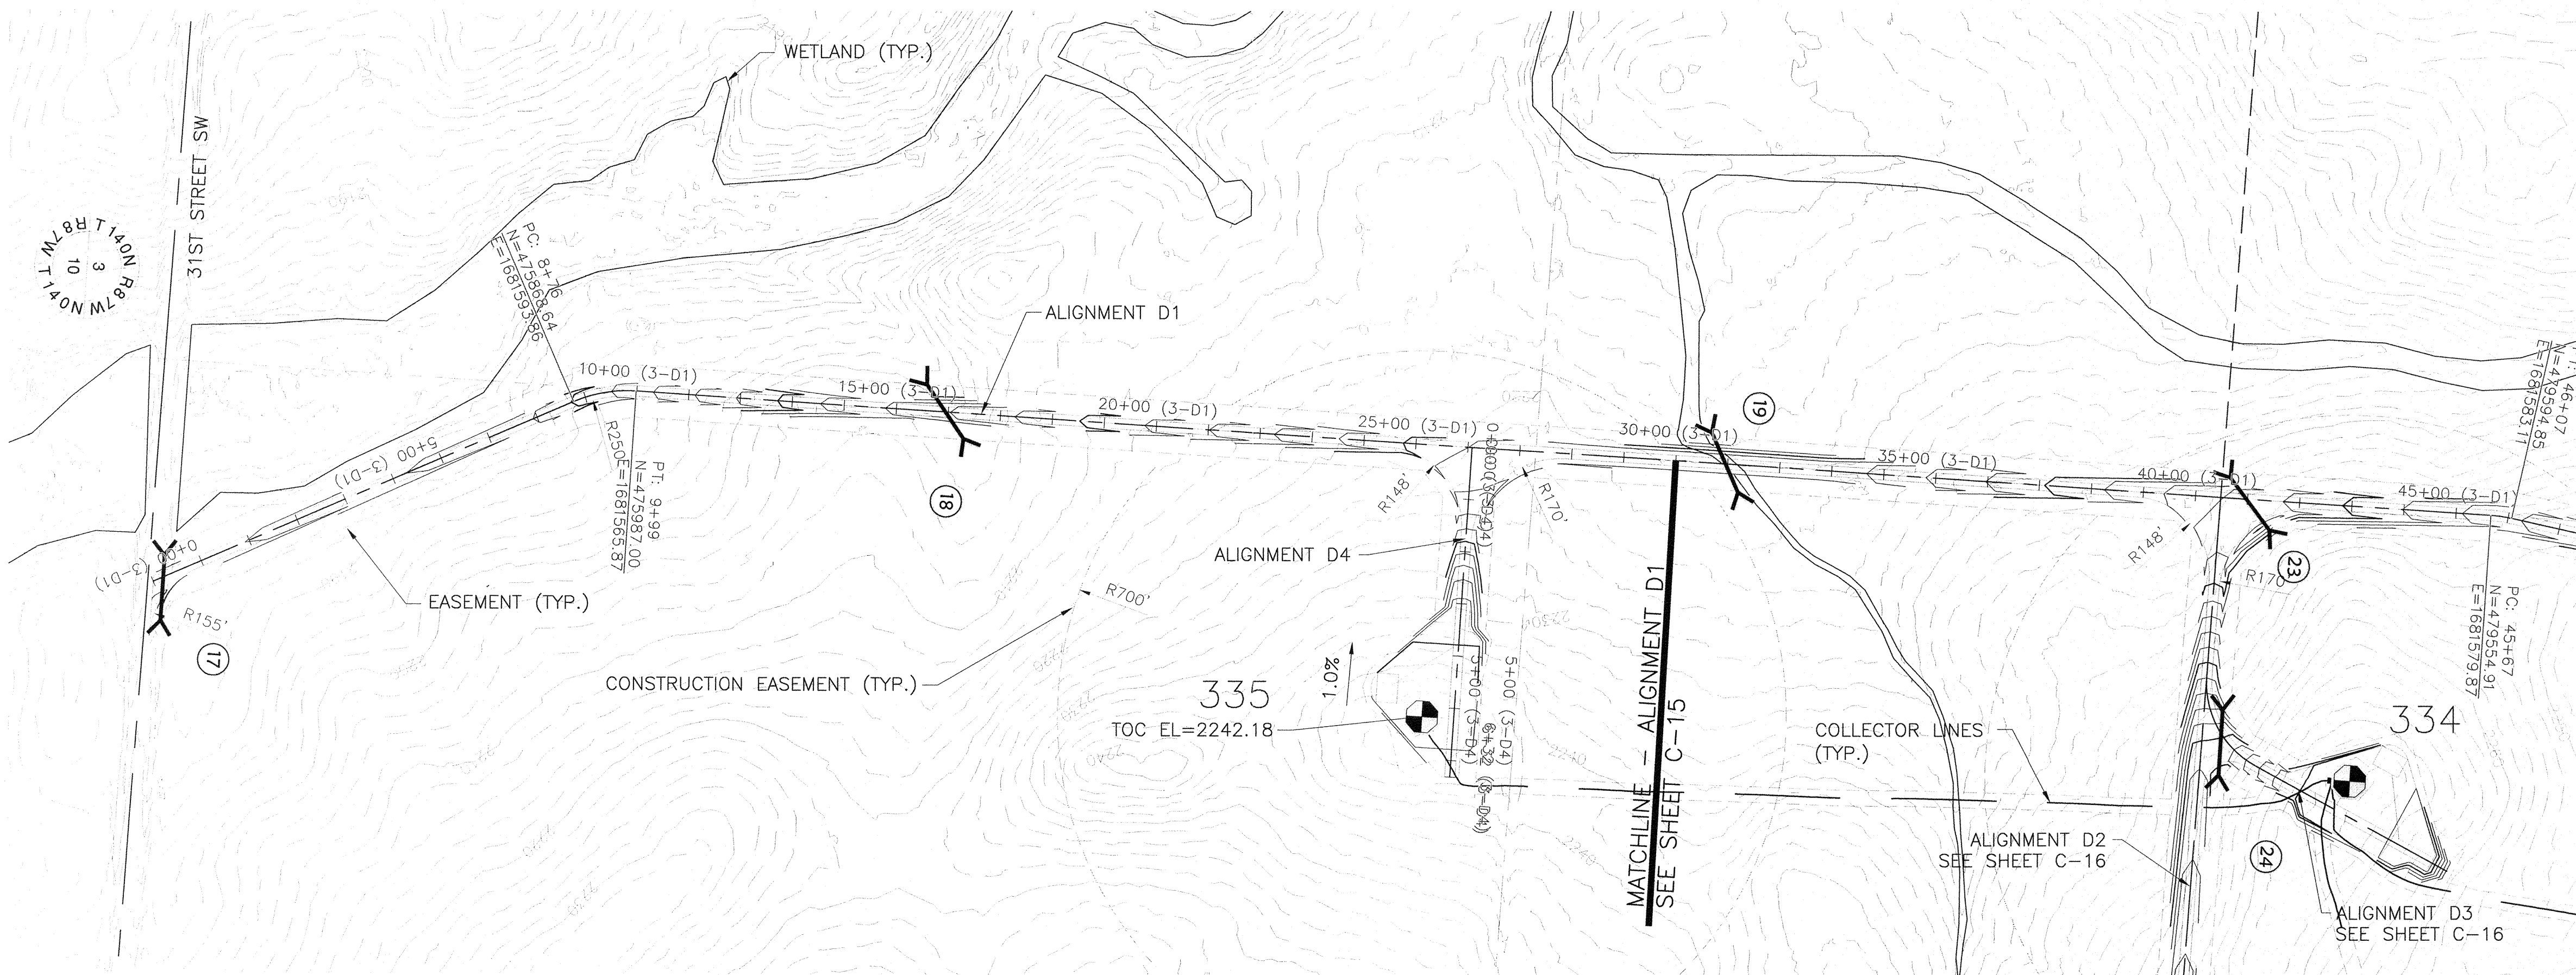


CLIENT	07/15/11	09/02/11					
BID							
CONSTRUCTION							
PERMITTING							
RECORD							
RELEASED TO/FOR	A	B	C	0	1	2	3
DATE RELEASED							

BARR
 Corporate Headquarters:
 Minneapolis, Minnesota
 Ph: 1-800-632-2277

Project Office:
BARR ENGINEERING CO.
 4700 WEST 77TH STREET
 MINNEAPOLIS, MN.
 55435-4803
 Ph: 1-800-632-2277
 Fax: (952) 832-2601
 www.barr.com

Scale	AS SHOWN
Date	07/05/11
Drawn	KKB
Checked	JXB
Designed	CAD
Approved	JXB

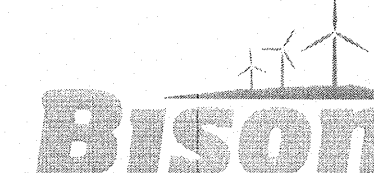

A WIND ENERGY INITIATIVE OF MINNESOTA POWER IN NORTH DAKOTA

BISON 3 WIND PROJECT
 MORTON & OLIVER COUNTIES, NORTH DAKOTA
 PLAN AND PROFILE - ALIGNMENTS D1 STA.
 0+00 TO 30+00 - D4 STA. 0+00 TO 6+32

BARR PROJECT No.	34/30-1006
CLIENT PROJECT No.	
DWG. No.	C-14
REV. No.	1