
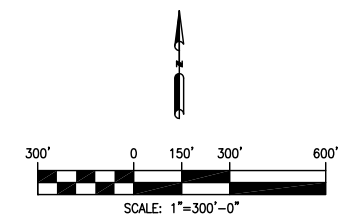


C:\Enbridge\BakkenPSC\Berthold\2840-BH-PSC-0001-Rail-NEW.dwg Allen.Jones 3/20/2014 11:19:41 AM

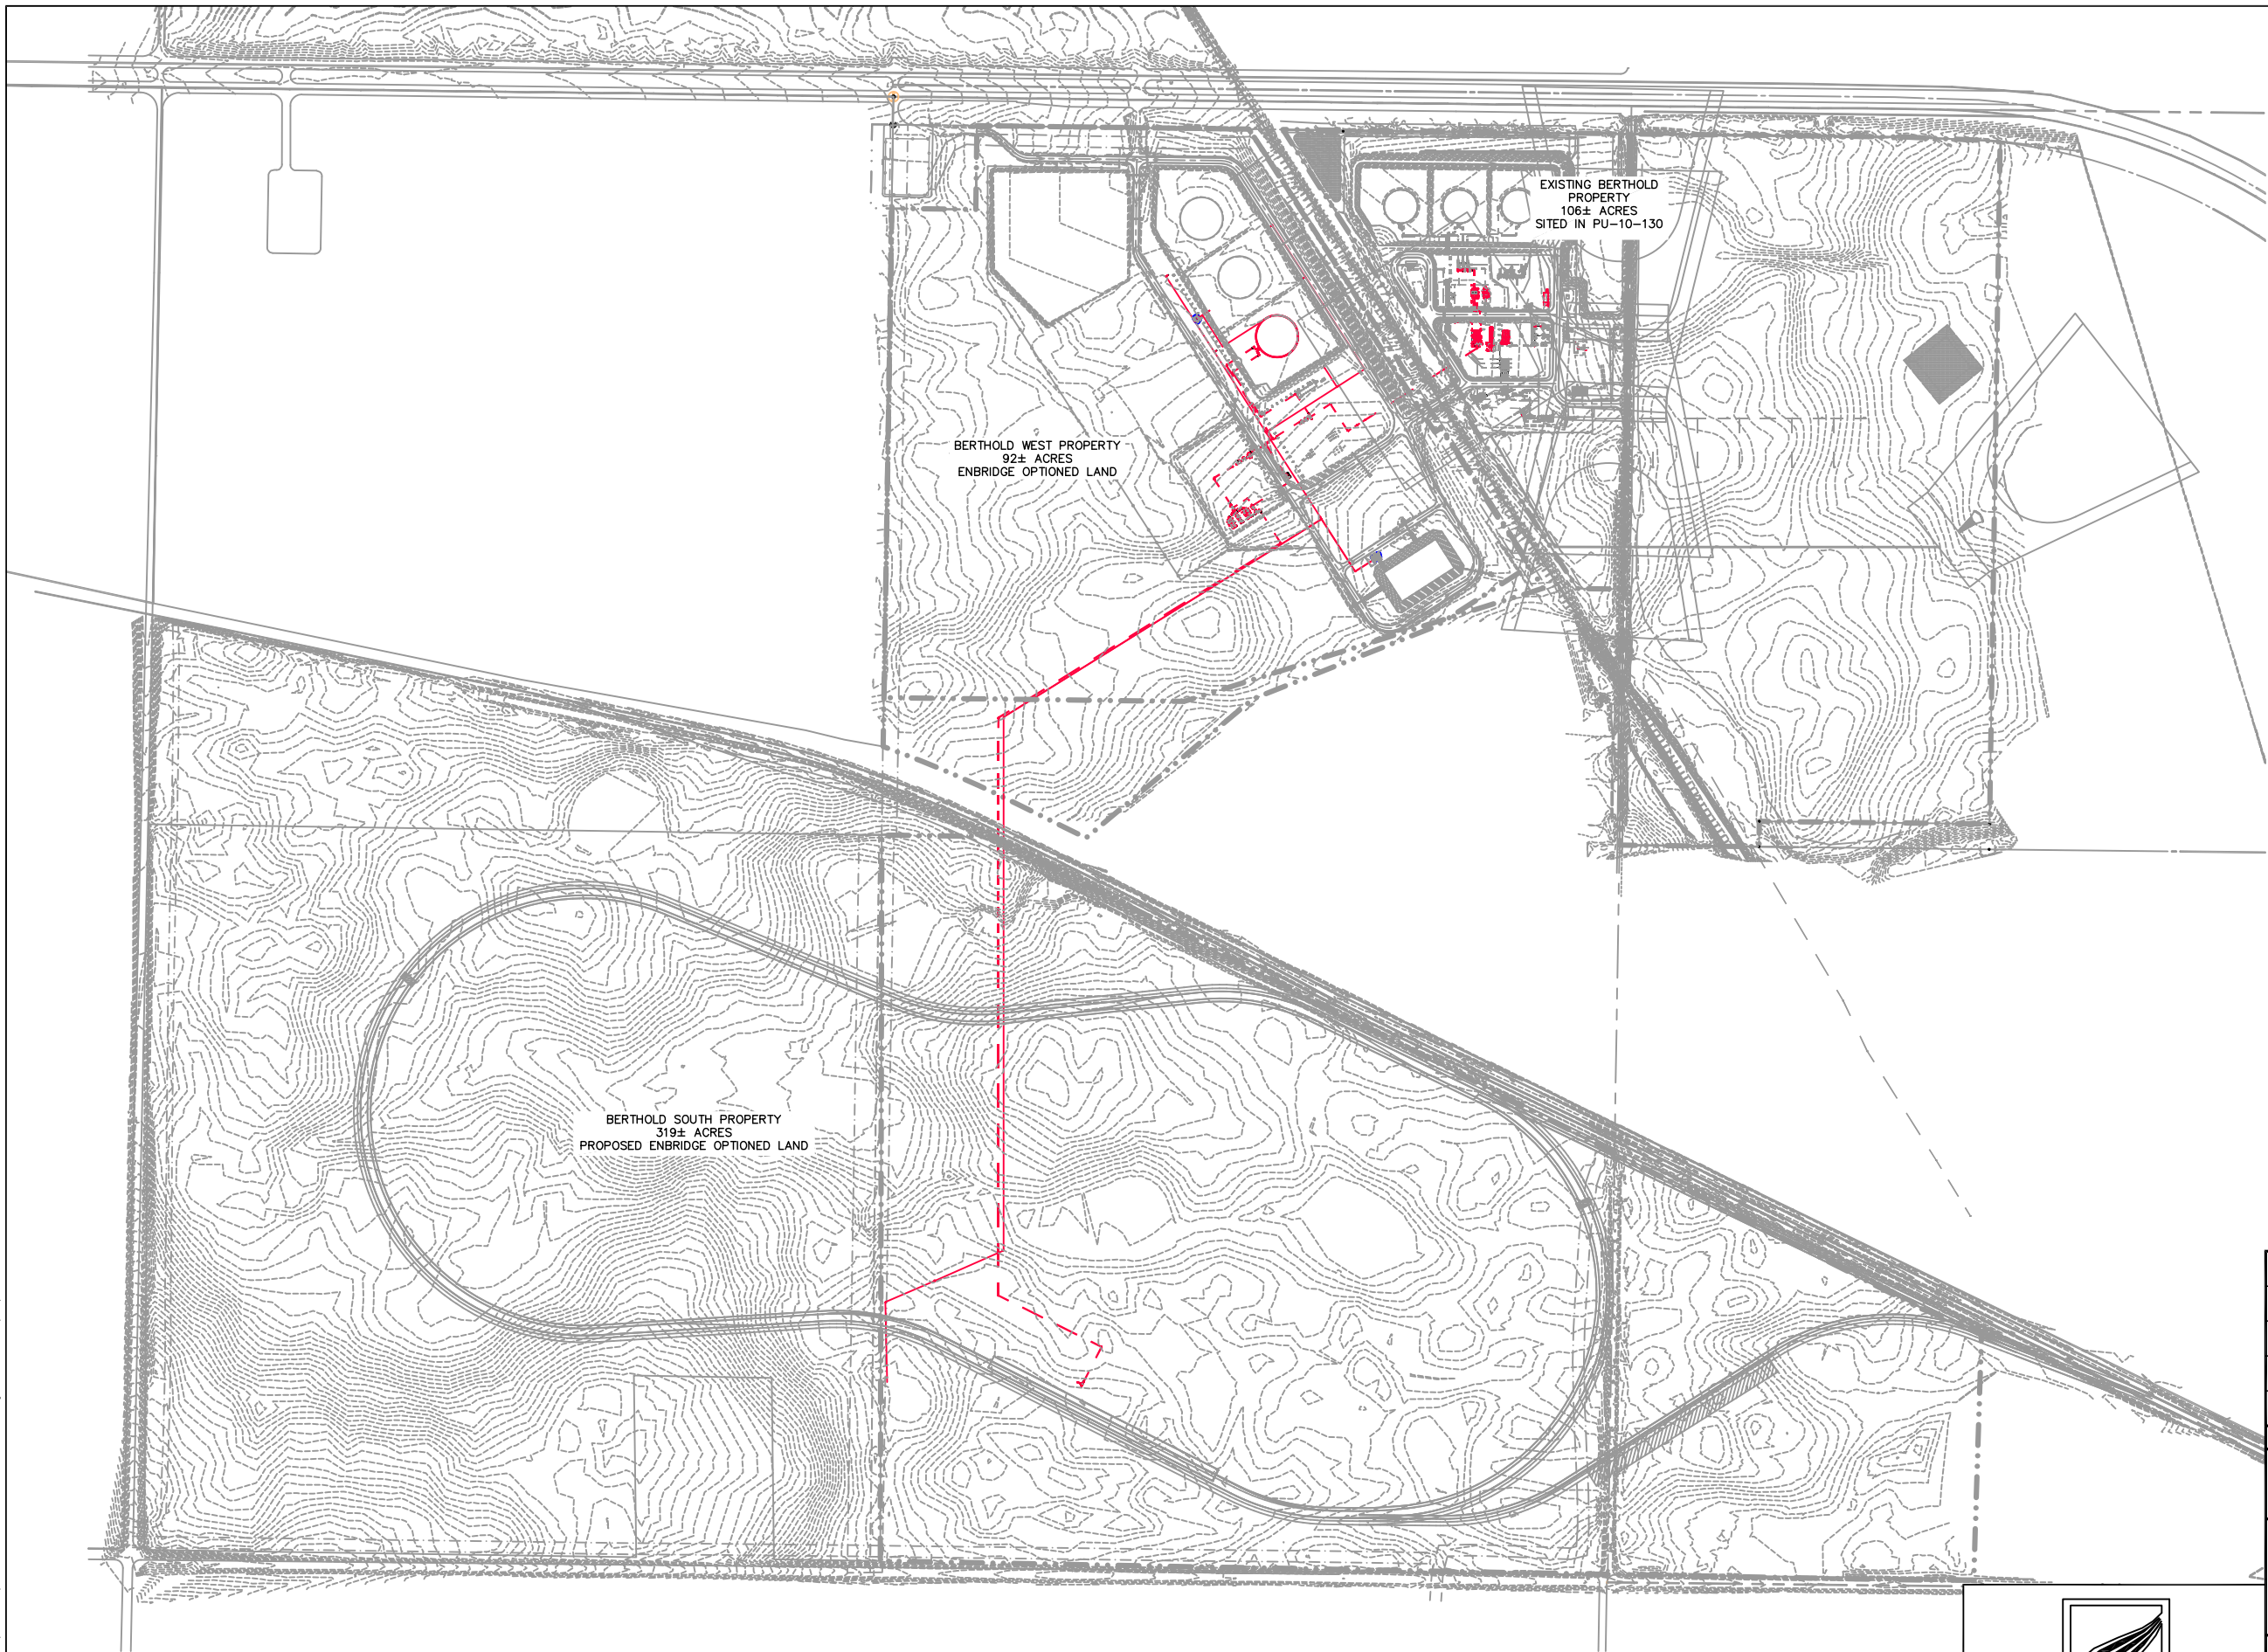

**LEGEND**

- BERTHOLD STATION EXPANSION PROJECT
- EXISTING

NO	REVISION	DATE	APPR	BY
1	AS-BUILT ISSUED FOR PSC FILING	03/21/14	LLF	SAS
0	ISSUED FOR PSC FILING	08/28/12	LLF	SAS

**NORTH DAKOTA PIPELINE COMPANY LLC**



**BERTHOLD (ND) STATION**  
BERTHOLD STATION EXPANSION PROJECT  
SITE PLAN

PROJECT: 2840-ENBRIDGE		
SCALE: AS NOTED	DATE: 08/28/12	DRAWN: SAS
CHECK: LLF	APPR: LLF	DATE: 03/21/14

**2840-BH-P-0001** **REV 1**

**Rooney Engineering, Inc.**  
12201 E. Arapahoe Rd.  
Centennial, CO 80112  
(303) 792-5911

C:\Enbridge\BakkenPSC\Berthold\2840-BH-PSC-00002-Rail-NEW.dwg Allen.Jones 3/20/2014 2:44:08 PM

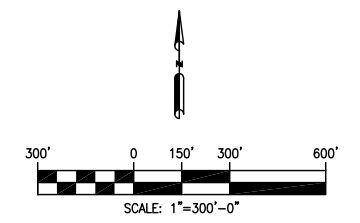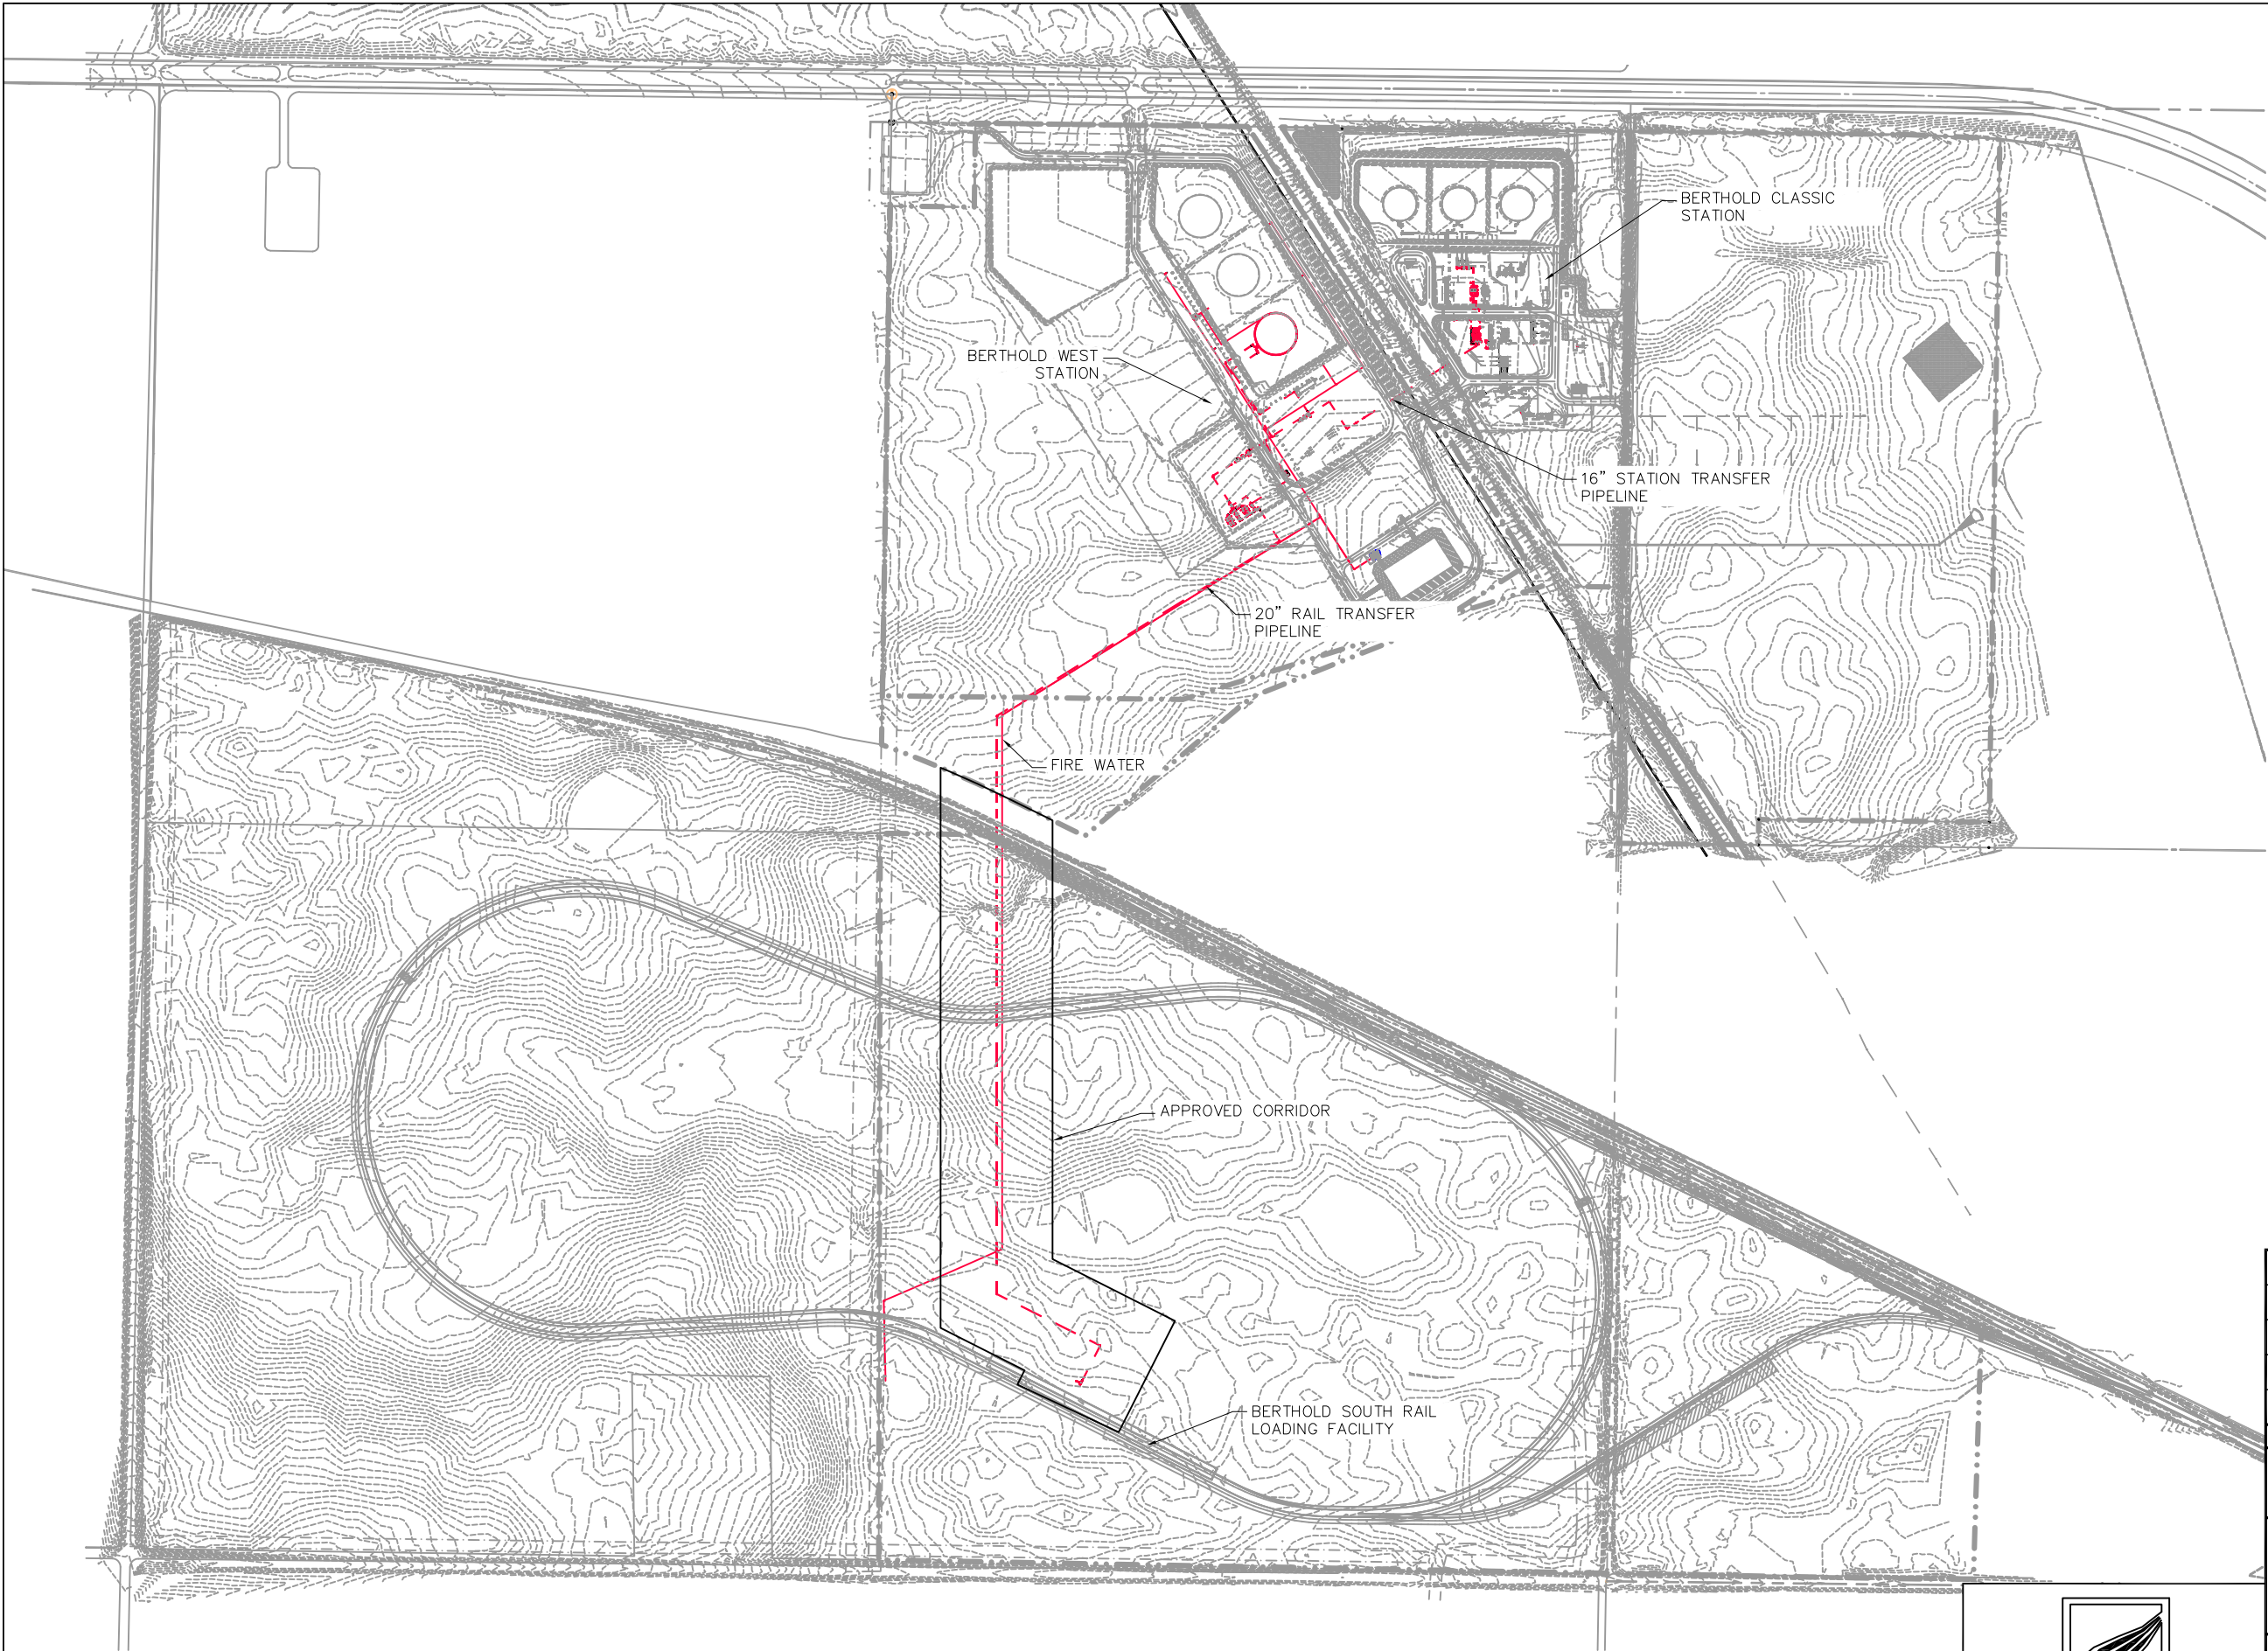

**LEGEND**  
 — BERTHOLD STATION EXPANSION PROJECT (JURISDICTIONAL)  
 — EXISTING

NO	REVISION	DATE	APPR	BY
1	AS-BUILT ISSUED FOR PSC FILING	03/21/14	LLF	SAS
0	ISSUED FOR PSC FILING	08/28/12	LLF	SAS



**NORTH DAKOTA PIPELINE COMPANY LLC**

**BERTHOLD (ND) STATION**  
 BERTHOLD STATION EXPANSION PROJECT  
 APPROVED CORRIDOR AERIAL

PROJECT: 2840-ENBRIDGE		
SCALE: AS NOTED	DATE: 08/28/12	DRAWN: SAS
CHECK: LLF	APPR: LLF	DATE: 03/21/14

**2840-BH-P-00002** **REV 1**

**Rooney Engineering, Inc.**  
 12201 E. Arapahoe Rd.  
 Centennial, CO 80112  
 (303) 792-5911

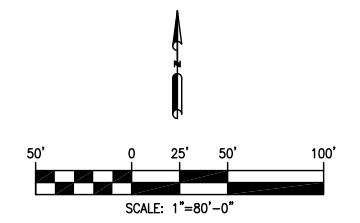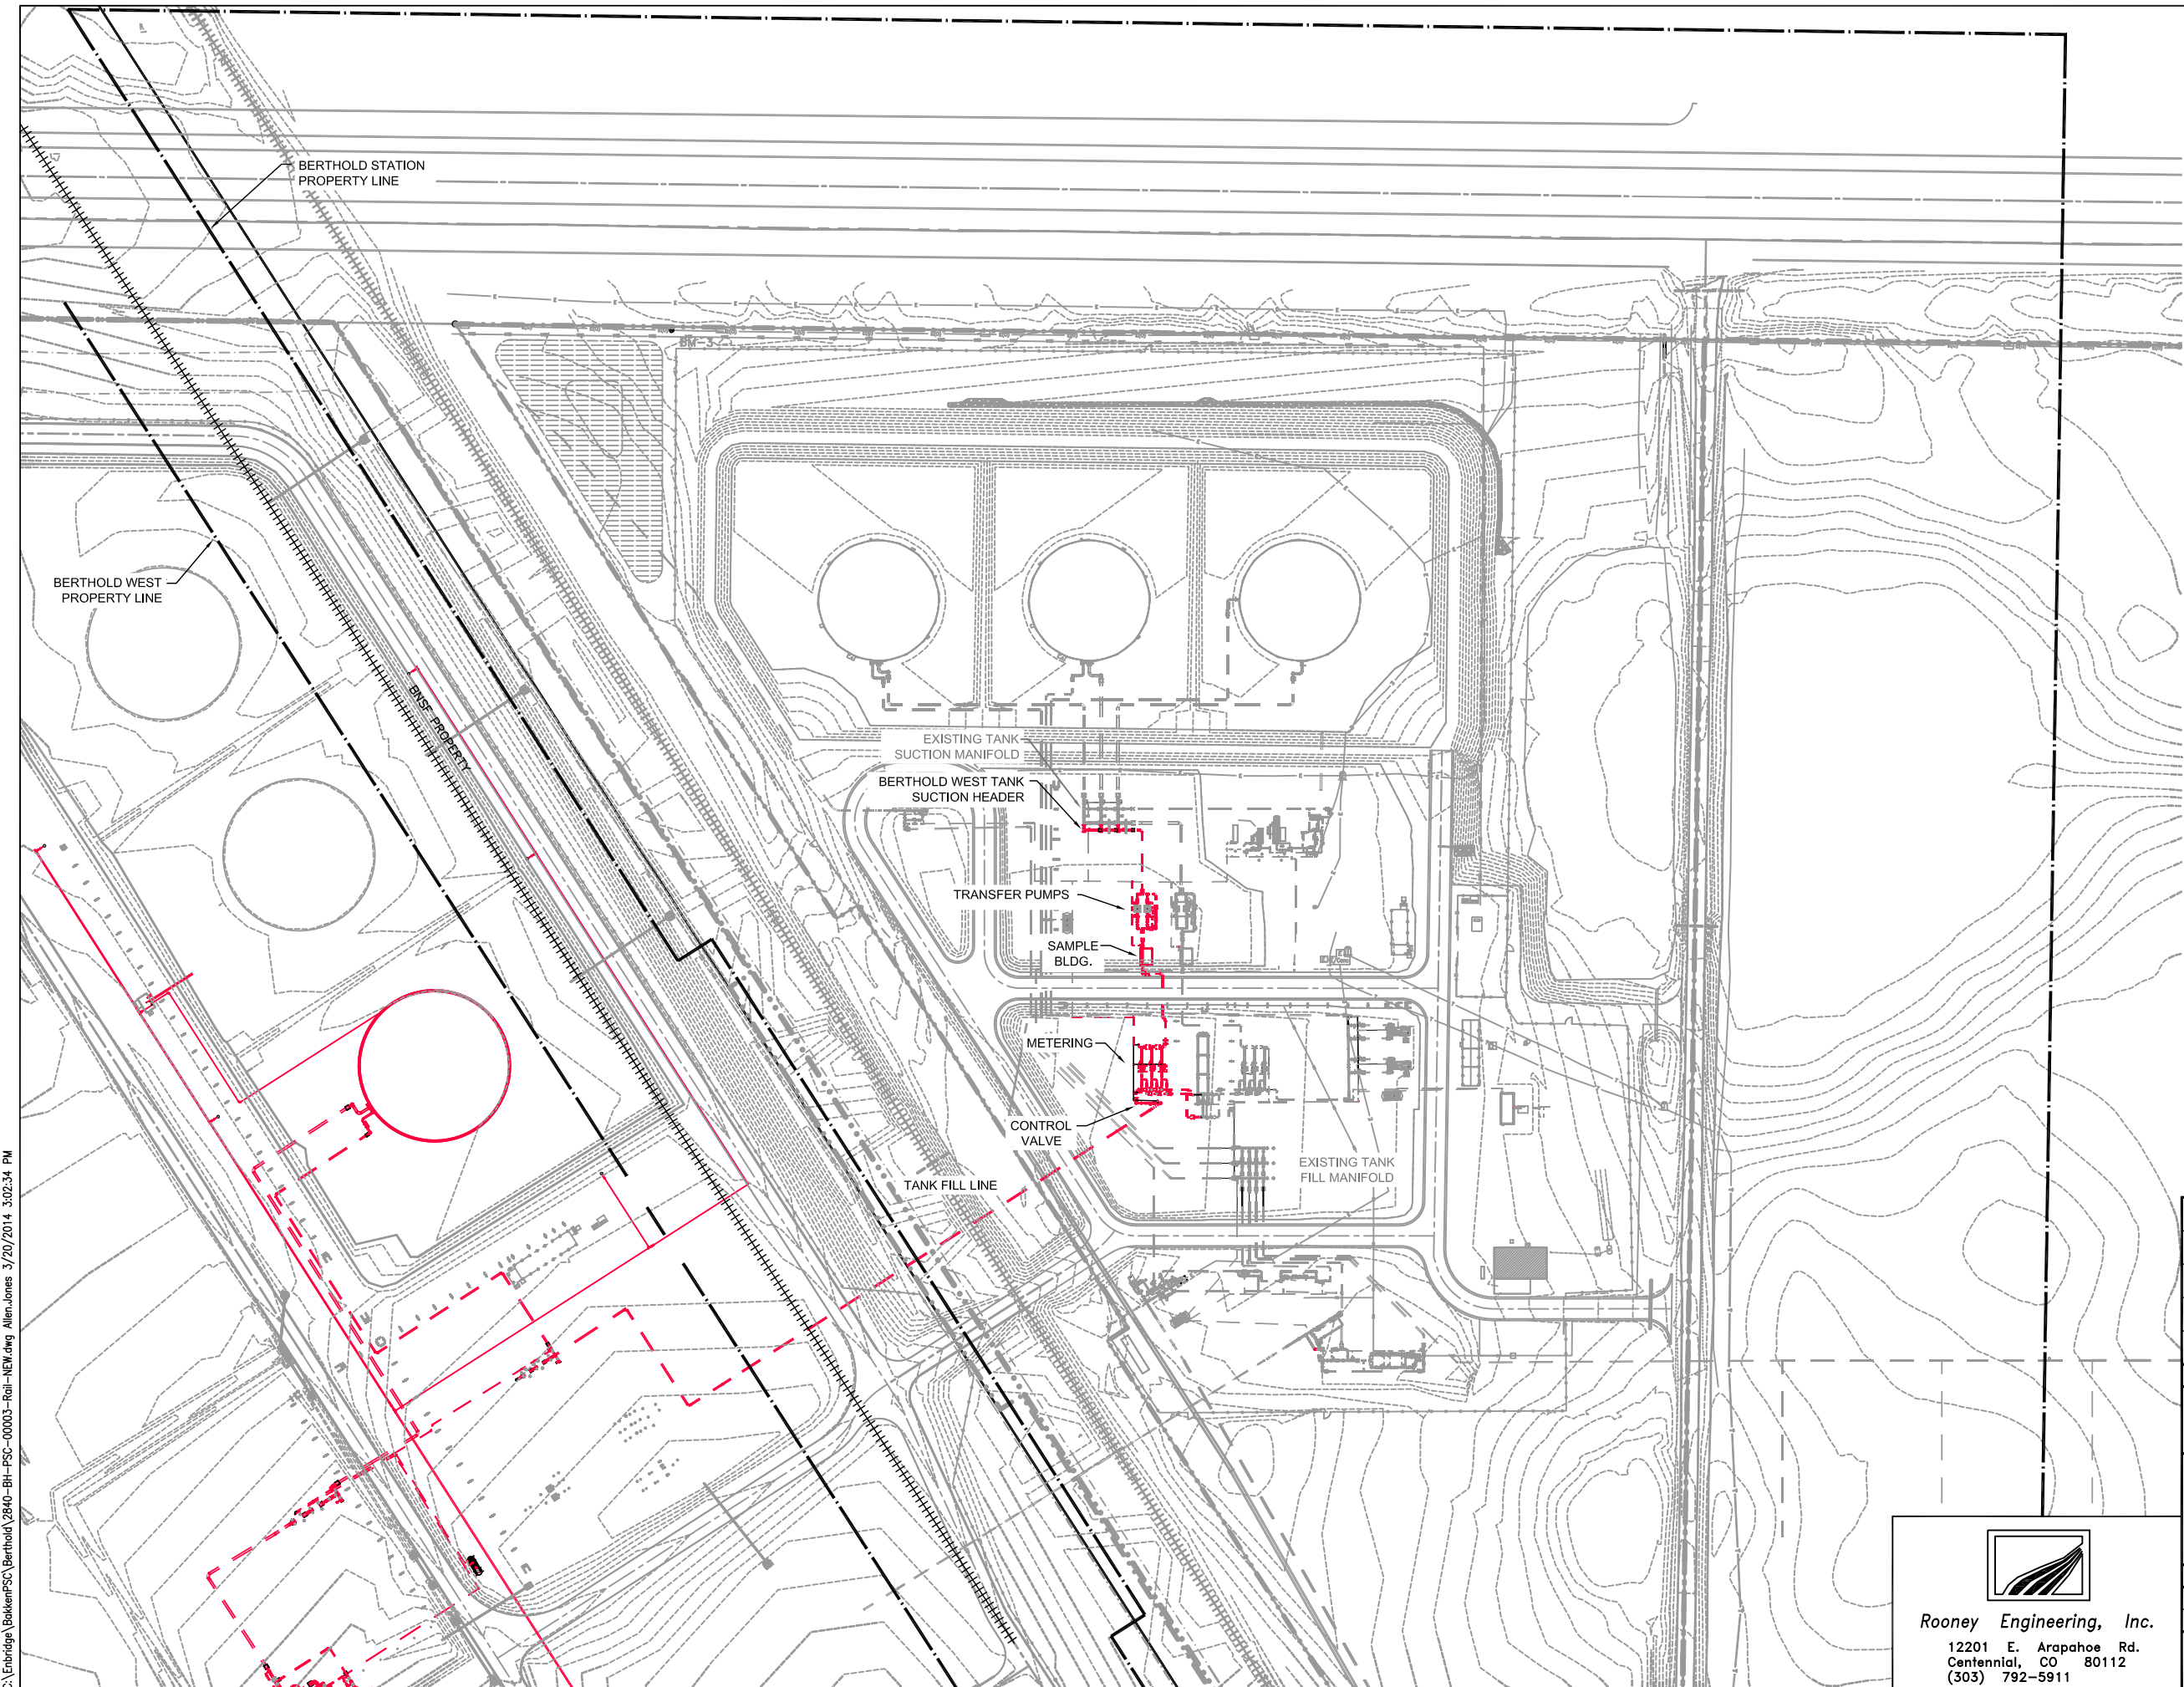

**LEGEND**

- BERTHOLD STATION EXPANSION PROJECT
- EXISTING

C:\Enbridge\BakkenPSC\Berthold\2840-BH-PSC-00003-Rail-NEW.dwg Allen Jones 3/20/2014 3:02:34 PM

NO	REVISION	DATE	APPR	BY
1	AS-BUILT ISSUED FOR PSC FILING	03/21/14	LLF	SAS
0	ISSUED FOR PSC FILING	08/28/12	LLF	SAS


**NORTH DAKOTA PIPELINE COMPANY LLC**

**BERTHOLD (ND) STATION**  
BERTHOLD STATION EXPANSION PROJECT  
BERTHOLD STATION PLOT PLAN

PROJECT: 2840-ENBRIDGE		
SCALE: AS NOTED	DATE: 08/28/12	DRAWN: SAS
CHECK: LLF	APPR: LLF	DATE: 03/21/14

**2840-BH-P-00003** **REV 1**

**Rooney Engineering, Inc.**  
12201 E. Arapahoe Rd.  
Centennial, CO 80112  
(303) 792-5911

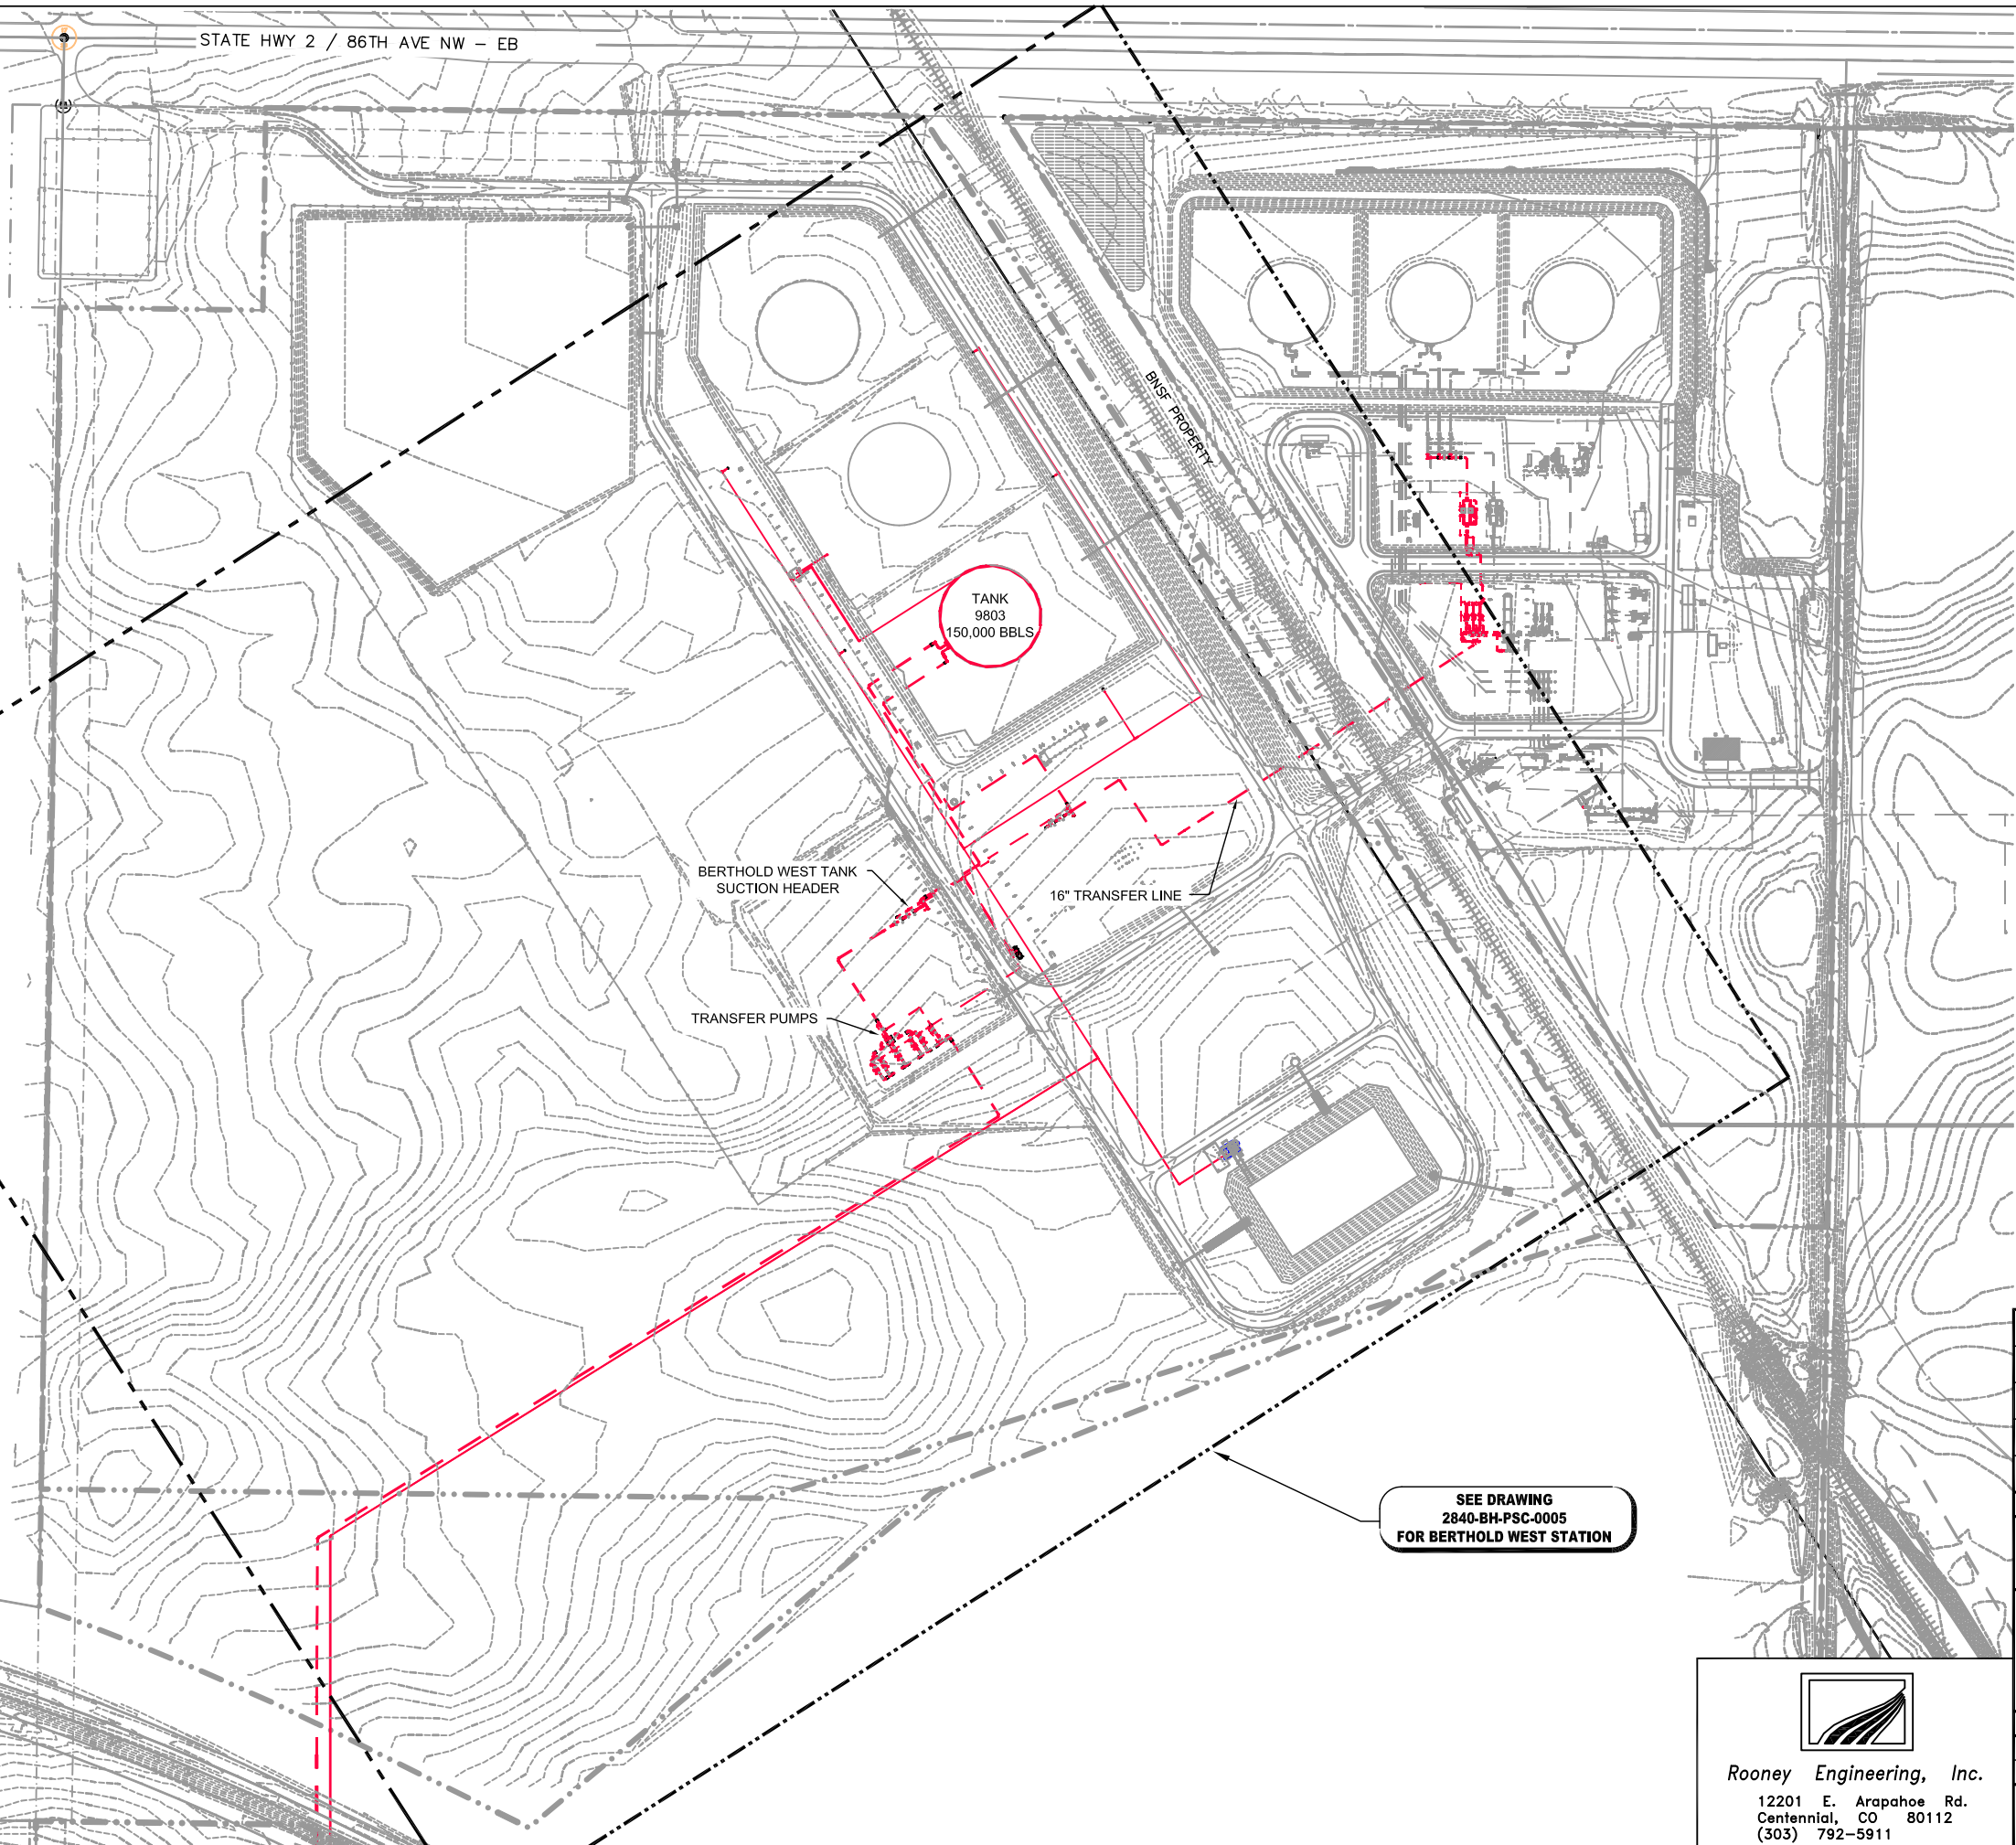

STATE HWY 2 / 86TH AVE NW - EB

BNSF PROPERTY


TANK  
9803  
150,000 BBLS

BERTHOLD WEST TANK  
SUCTION HEADER

16" TRANSFER LINE

TRANSFER PUMPS

SEE DRAWING  
2840-BH-PSC-0005  
FOR BERTHOLD WEST STATION

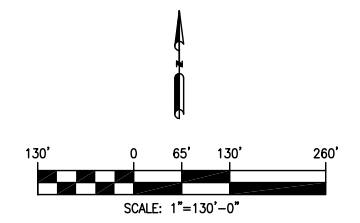

LEGEND

- BERTHOLD STATION EXPANSION PROJECT
- EXISTING

NO	REVISION	DATE	APPR	BY
1	AS-BUILT ISSUED FOR PSC FILING	03/21/14	LLF	SAS
0	ISSUED FOR PSC FILING	08/28/12	LLF	SAS

**NORTH DAKOTA PIPELINE COMPANY LLC**


**BERTHOLD (ND) STATION**  
BERTHOLD STATION EXPANSION PROJECT  
BERTHOLD STATION PLOT PLAN

PROJECT: 2840-ENBRIDGE		
SCALE: AS NOTED	DATE: 08/28/12	DRAWN: SAS
CHECK: LLF	APPR: LLF	DATE: 03/21/14

**2840-BH-P-00004** REV 1


**Rooney Engineering, Inc.**  
12201 E. Arapahoe Rd.  
Centennial, CO 80112  
(303) 792-5911

C:\Enbridge\BakkenPSC\Berthold\2840-BH-PSC-00004-Rail-NEW.dwg Allen.Jones 3/20/2014 3:05:41 PM

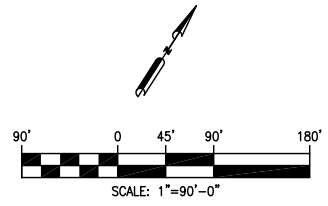

**LEGEND**

- BERTHOLD STATION EXPANSION PROJECT
- EXISTING

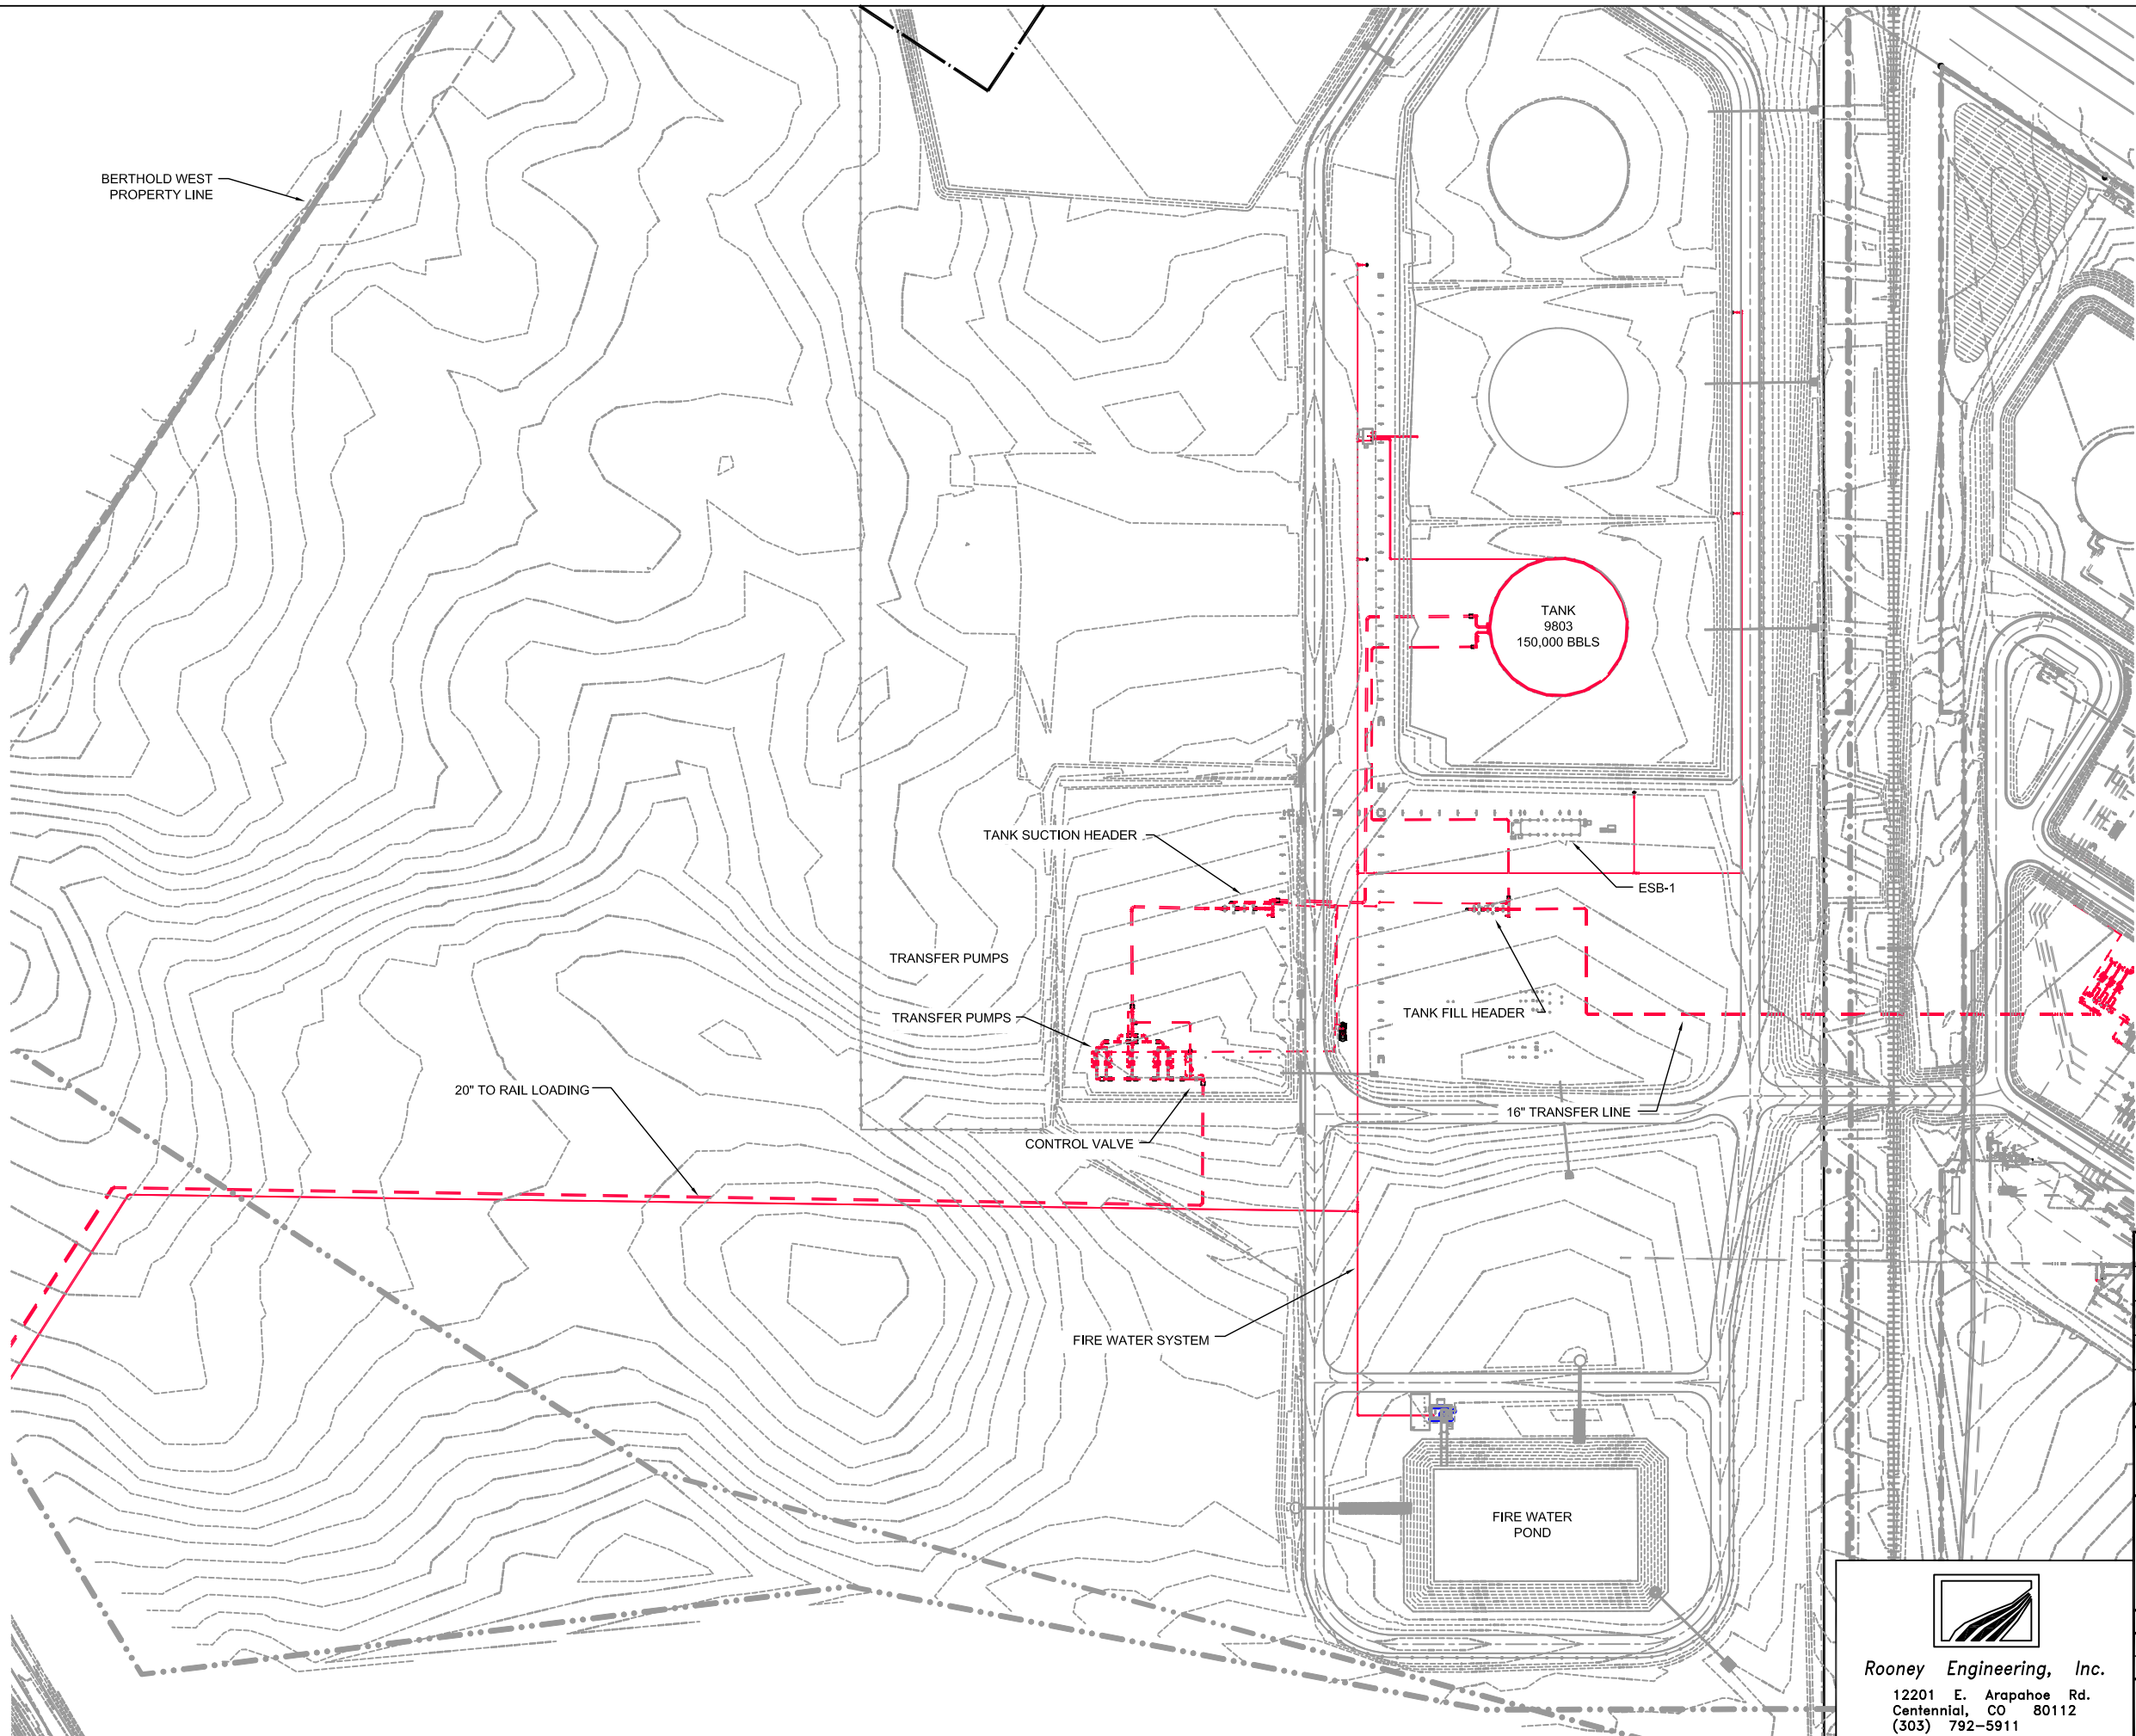


NO	REVISION	DATE	APPR	BY
1	AS-BUILT ISSUED FOR PSC FILING	03/21/14	LLF	SAS
0	ISSUED FOR PSC FILING	08/28/12	LLF	SAS

**NORTH DAKOTA PIPELINE COMPANY LLC**

**BERTHOLD (ND) STATION**  
BERTHOLD STATION EXPANSION PROJECT  
BERTHOLD STATION PLOT PLAN

PROJECT: 2840-ENBRIDGE		
SCALE: AS NOTED	DATE: 08/28/12	DRAWN: SAS
CHECK: LLF	APPR: LLF	DATE: 03/21/14

**2840-BH-P-00005** **REV 1**



**Rooney Engineering, Inc.**  
12201 E. Arapahoe Rd.  
Centennial, CO 80112  
(303) 792-5911

C:\Enbridge\BakkenPSC\Berthold\2840-BH-PSC-00005-Rail-NEW.dwg Allen.Jones 3/20/2014 2:52:44 PM